

PLAN SHOWING THE REVISED BLOCK - I (EXISTING) AND PROPOSED BLOCK - II AND PROPOSED BLOCK - III CONSTRUCTION OF RCC ROOF SCHOOL BUILDING FOR "M/s.AVVAI MATRIC. HR. SEC.SCHOOL" IN S.F.No:440/2C2, POLAIYAMPALLI VILLAGE AND PANCHAYAT, MORAPPUR PANCHAYAT UNION, HARRUR TALUK AND DHARMAPURI DISTRICT.

ALL DIMENSIONS ARE IN "METER" SCALE 1:100



EXISTING APPROVED DETAILS :-

1. DTCP DHARMAPURI - FILE No :771/2019, DT : 29.04.2019.
2. SITE APPROVAL : டி.வந்த.து.இ(தம)எண்:47/2019
3. BUILDING APPROVAL : க.வந்த.து.இ(தம)எண்: 8.அ.ஆ / 2019

Area Details

EXISTING APPROVED BUILDING AREA DETAILS

Particulars	Total Buildup Area Sq.mt	Non FSI Area Deduction Sq.mt	Total FSI Area Sq.mt
Area of Ground Floor	817.94	-	817.94
Area of First Floor	777.92	-	777.92
Area of Second Floor	777.92	-	777.92
Area of Head Room	70.25	70.25	-
Total Area	2444.03	70.25	2373.78

REVISED BUILDING AREA DETAILS

Particulars	Total Buildup Area Sq.mt	Non FSI Area Deduction Sq.mt	Total FSI Area Sq.mt
BLOCK - I			
Revised Approval			
Area of Ground Floor	835.64	-	835.64
Area of First Floor	791.42	-	791.42
Area of Second Floor	791.42	-	791.42
Area of Head Room	109.58	109.58	-
Total Area	2528.06	109.58	2418.48

Schedule of Joineries

D	Door	1.23 X 2.15
D1	Door	0.80 X 2.15
S.D	Sliding Door	0.90 X 2.15
S.D1	Steel Door	1.20 X 2.15
W	Window	1.22 X 1.40
J	Jolly	4.42 X 1.40
J1	Jolly	2.38 X 1.40
V	Ventilator	4.42 X 0.60
V1	Ventilator	0.80 X 0.60

KEY

EL	EMERGENCY LIGHT	FE	FIRE EXTINGUISHER
FA	FIRE ALARM	LB	LONG BELL
FH	FIRE HYDRANT	DW	DRINKING WATER

OFFICE USE

Site Approval

Online Application(SWP) No. SWP/BPA/059265/2023

Site Boundary shown as **A to E** and numbered as L.P/A.D.TCP (Dharmapuri) **No:125/2023**

Site Approval issued.

Technical Approval

Online Application(SWP) No. SWP/BPA/059265/2023

B.P/A.D.TCP (Dharmapuri) **No:27/2023**

Technical Approval issued.

D. Uma

APPLICANT

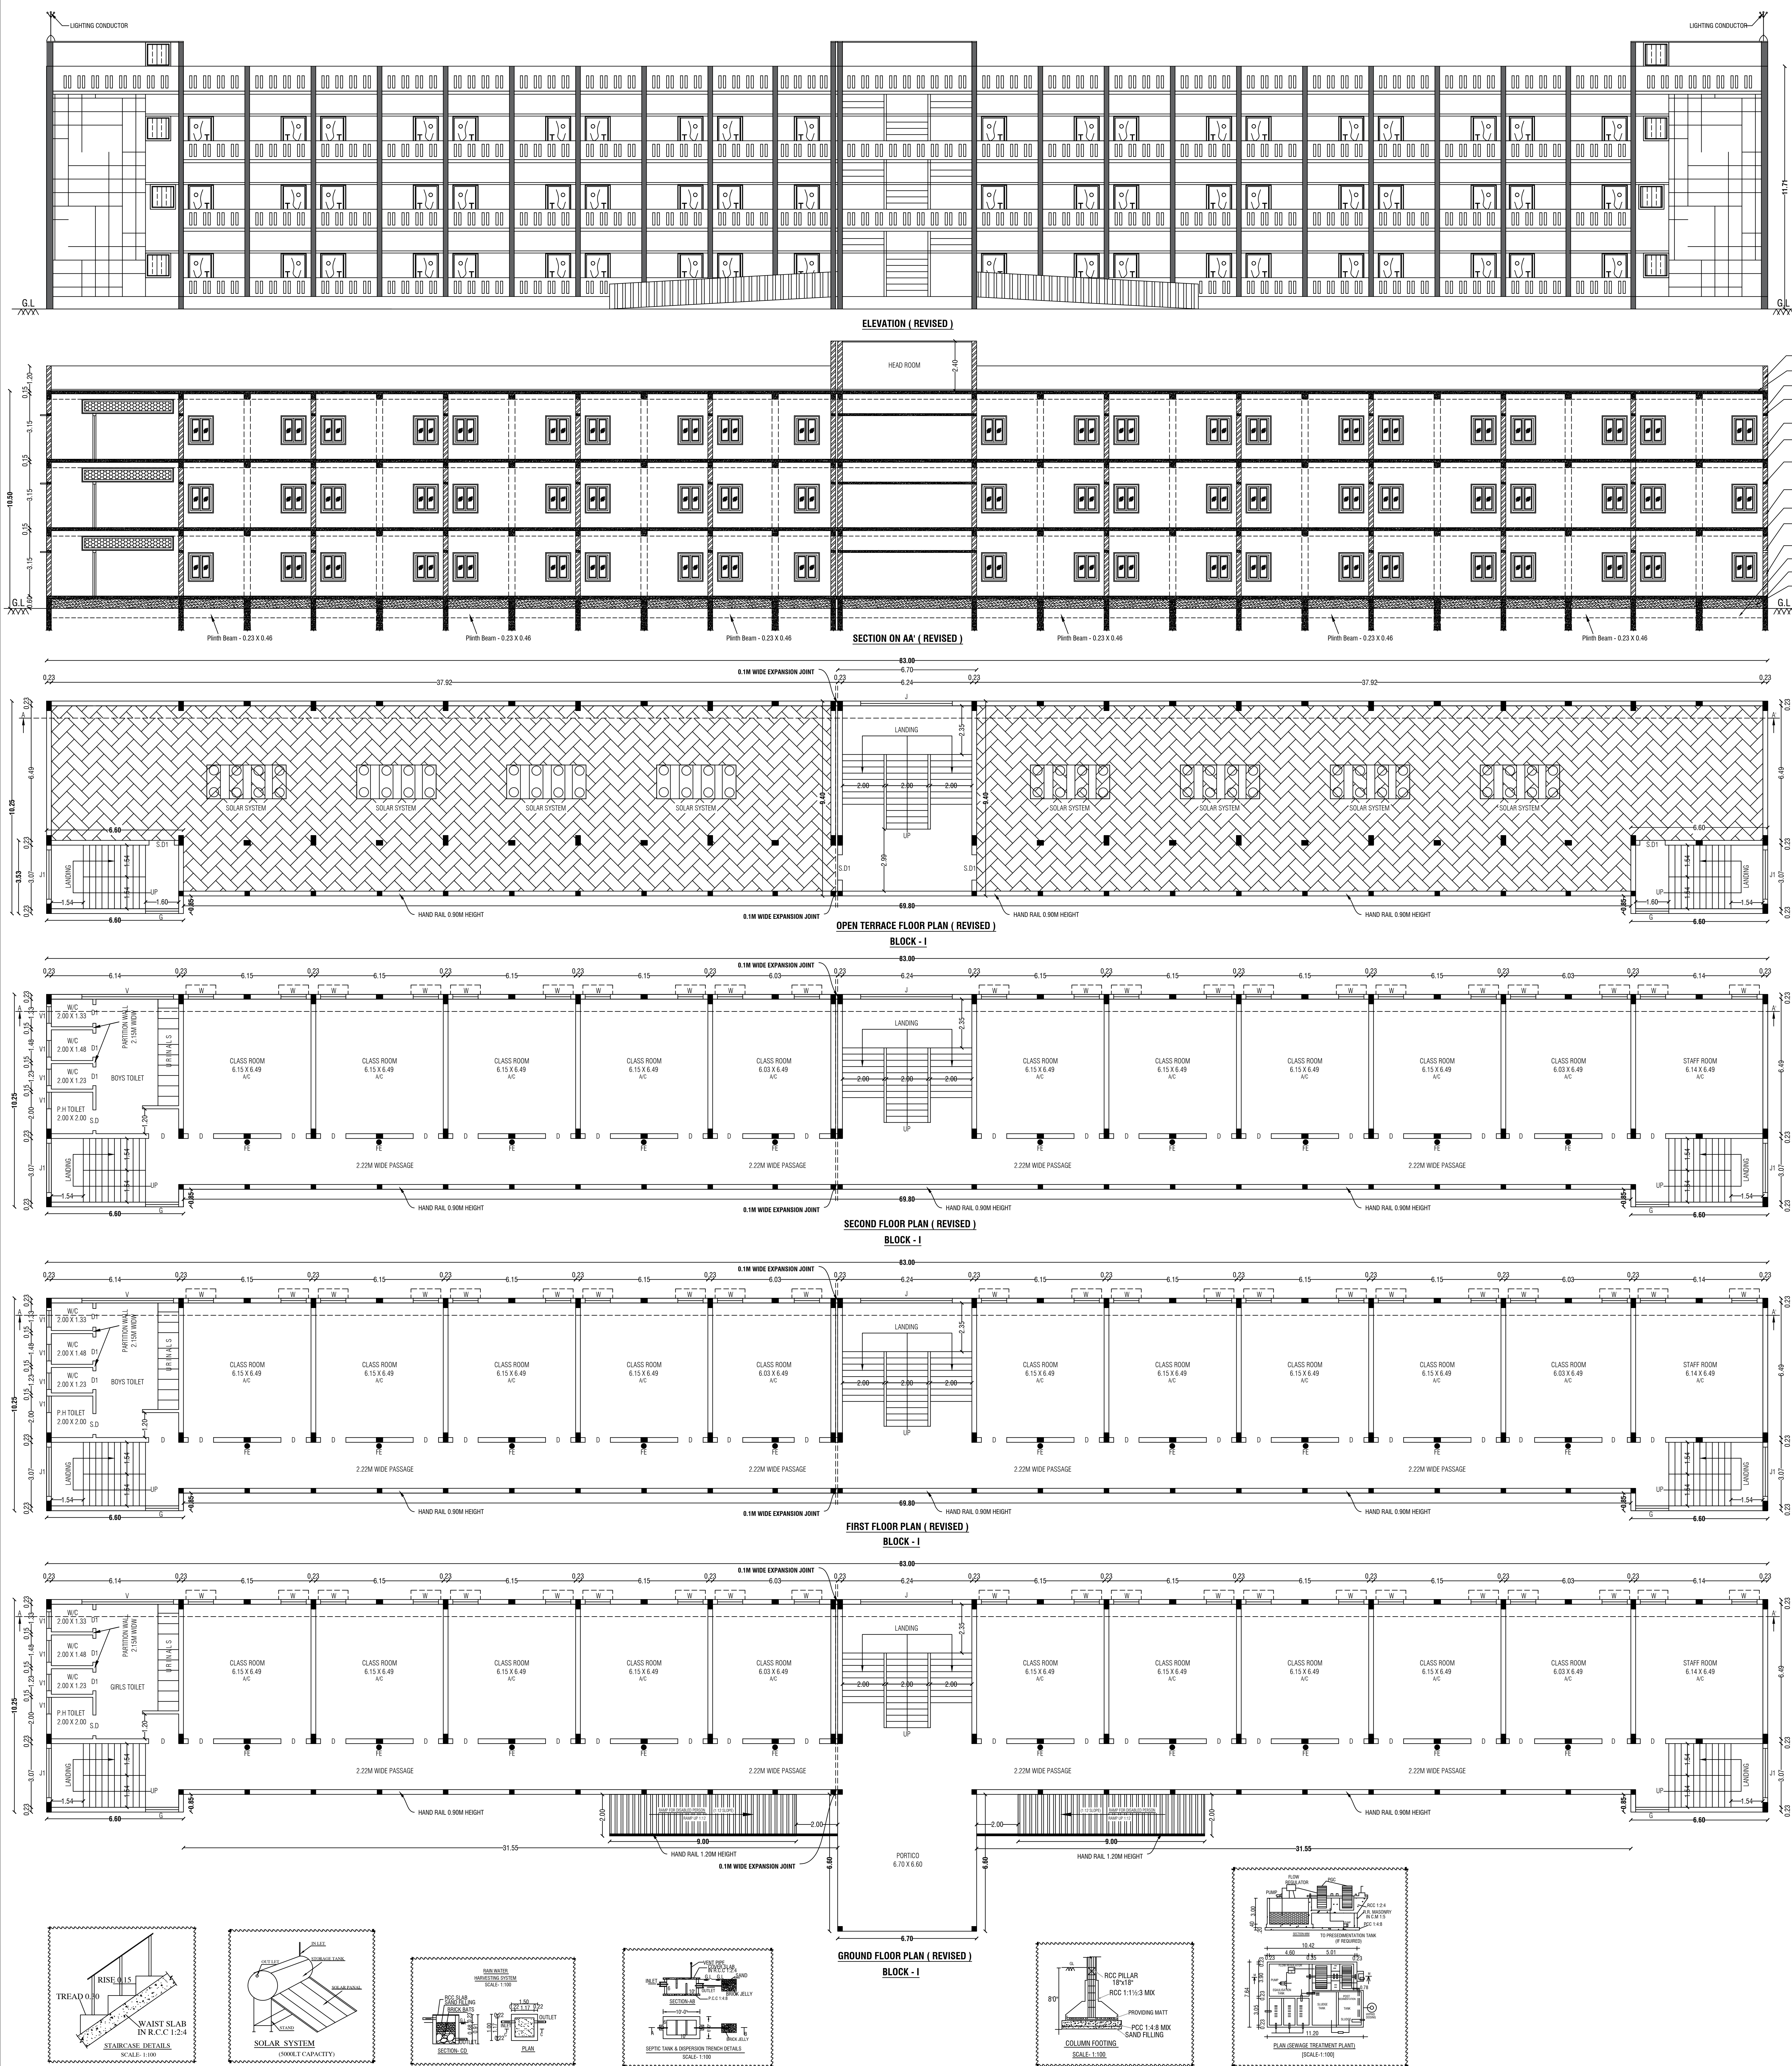
Er.M.VADIVEL.ME(Struct.), AMIE., C.Eng(I), MISTE., AIV.,
Consulting Civil Engineer, Chartered Engineer,
TN.Govt. Registered Professional of DTCP,
R.E-II-01/2023, R.S.E-II-21/2020, R.C.E-27/2020, R.D-06/2020,
R.E.(G-3), DMC No.037/LS/2019/00004, CCMC No.004/2021,
DMV CONSTRUCTION.
#19/17, 1st Floor, Annamalai Street, Near Municipality Office,
Dharmapuri - 636701, Cell: 8122 101 282, 9443 101 282.
E-Mail : dmconstruction.dp@gmail.com

REGISTERED STRUCTURAL ENGINEER

Er.M.VADIVEL.ME(Struct.), AMIE., C.Eng(I), MISTE., AIV.,
Consulting Civil Engineer, Chartered Engineer,
TN.Govt. Registered Professional of DTCP,
R.E-II-01/2023, R.S.E-II-21/2020, R.C.E-27/2020, R.D-06/2020,
R.E.(G-3), DMC No.037/LS/2019/00004, CCMC No.004/2021,
DMV CONSTRUCTION.
#19/17, 1st Floor, Annamalai Street, Near Municipality Office,
Dharmapuri - 636701, Cell: 8122 101 282, 9443 101 282.
E-Mail : dmconstruction.dp@gmail.com

REGISTERED ENGINEER

Er.M.Vadivel. ME(Struct.), AMIE., C.Eng(I), MISTE., AIV., - D.M.V Construction - 8122 101 282, 9443 101 282



PLAN SHOWING THE REVISED BLOCK - I (EXISTING) AND

PROPOSED BLOCK - II AND PROPOSED BLOCK - III CONSTRUCTION

OF RCC ROOF SCHOOL BUILDING FOR "M/s.AVVAI MATRIC. HR.

 
SEC.SCHOOL" IN S.F.No:440/2C2, POLAYAMPALLI VILLAGE AND

PANCHAYAT, MORAPPUR PANCHAYAT UNION, HARRUR TALUK

AND DHARMAPURI DISTRICT.

ALL DIMENSIONS
ARE IN "METER"

SCALE 1:100

**EXISTING APPROVED DETAILS :-**

1. DTCP DHARMAPURI - FILE No :771/2019, DT : 29.04.2019.
2. SITE APPROVAL : டி.வ/ந.ஊ.து.இ(தம)எண்:47/2019
3. BUILDING APPROVAL : க.வ/ந.ஊ.து.இ(தம)எண்: 8.அ.ஆ / 2019

Proposed Area Details

Particulars	Total Buildup Area Sq.mt	Non FSI Area Deduction Sq.mt	Total FSI Area Sq.mt
BLOCK - II			
Area of Ground Floor	437.81	-	437.81
Area of First Floor	414.77	-	414.77
Area of Second Floor	336.25	-	336.25
Area of Head Room	38.77	38.77	-
TOILET BLOCK - III			
Area of Ground Floor	68.85	-	68.85
Total Area	1296.45	38.77	1257.68

OFFICE USE

Site Approval

Online Application(SWP) No. SWP/BPA/059265/2023

Site Boundary shown as A to E

and numbered as L.P/A.D.TCP (Dharmapuri)

No:125/2023

Site Approval issued.

Technical Approval

Online Application(SWP) No. SWP/BPA/059265/2023

B.P/A.D.TCP (Dharmapuri) No:27/2023

Technical Approval issued.

D. Uma

APPLICANT

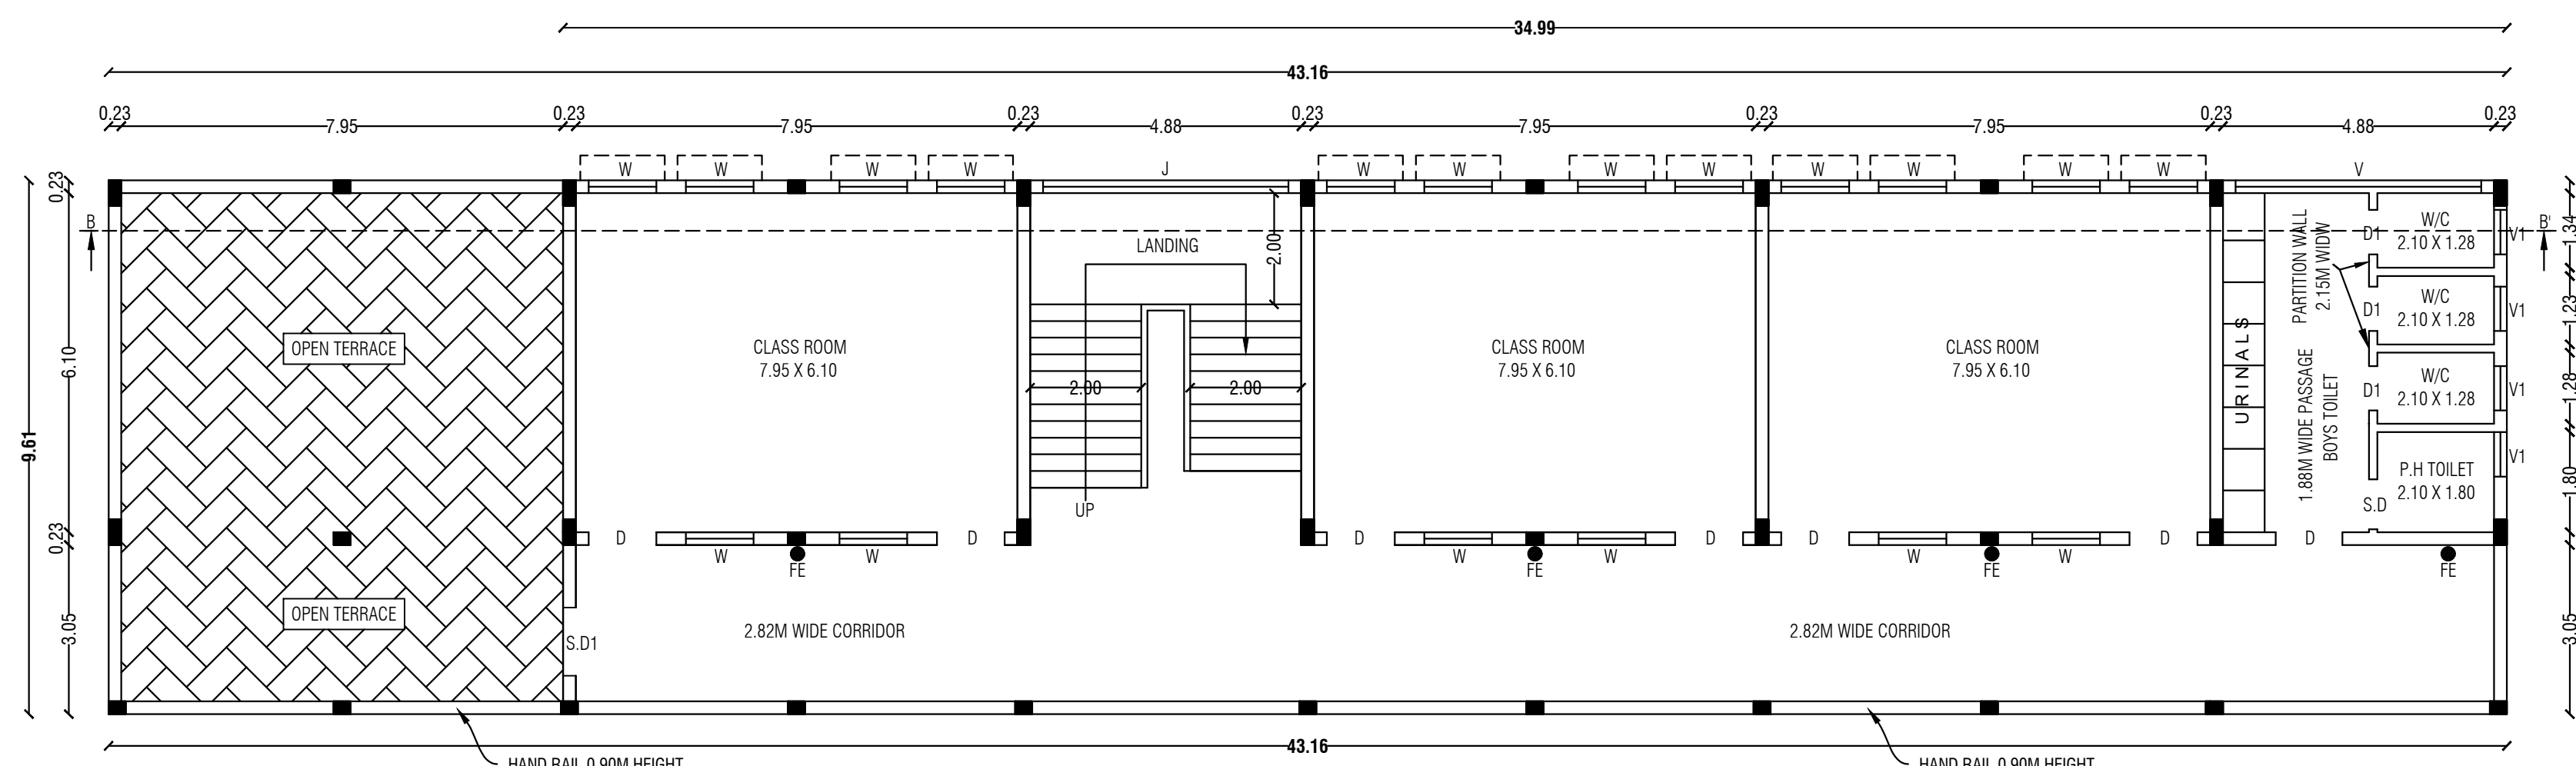
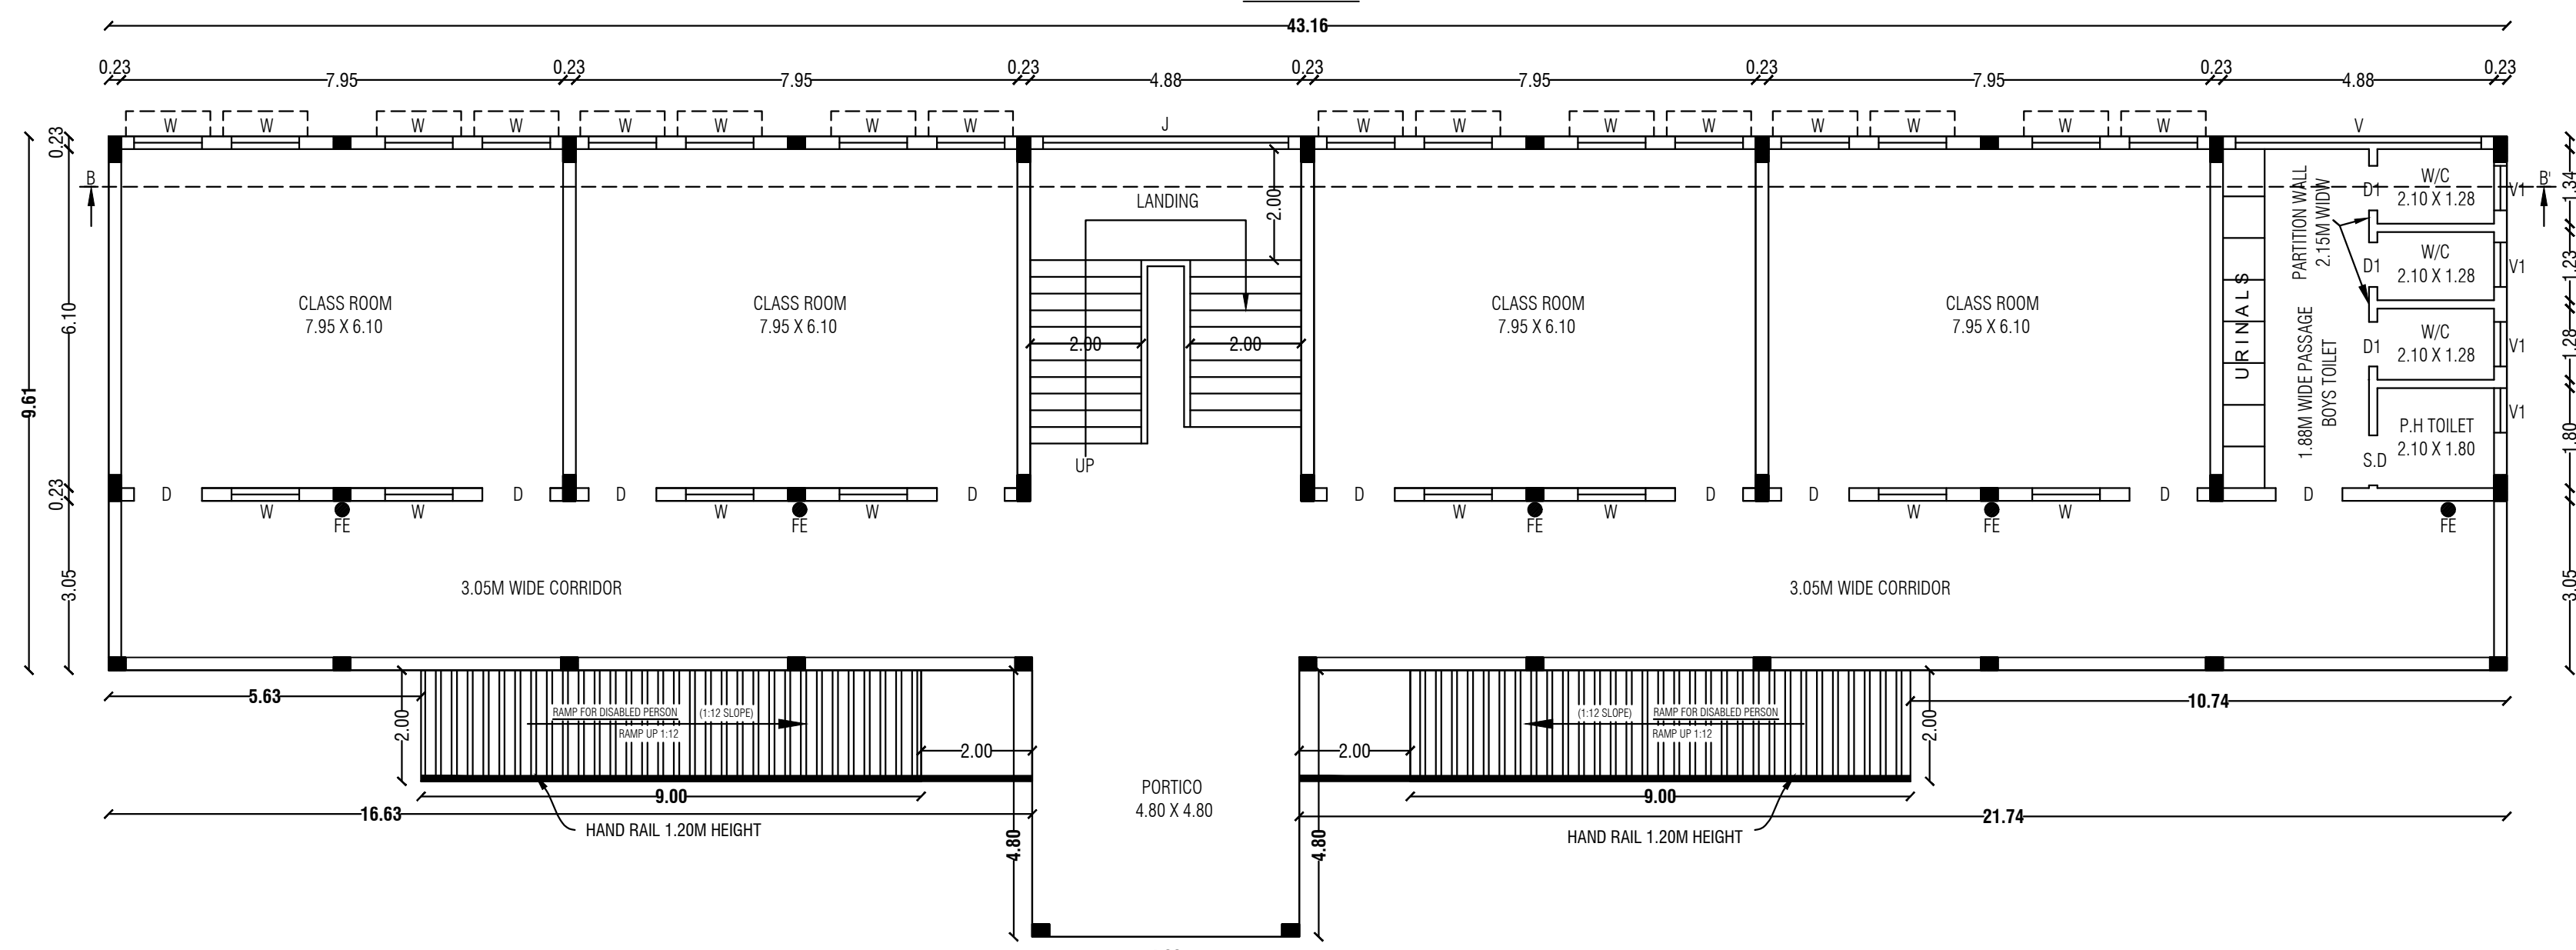
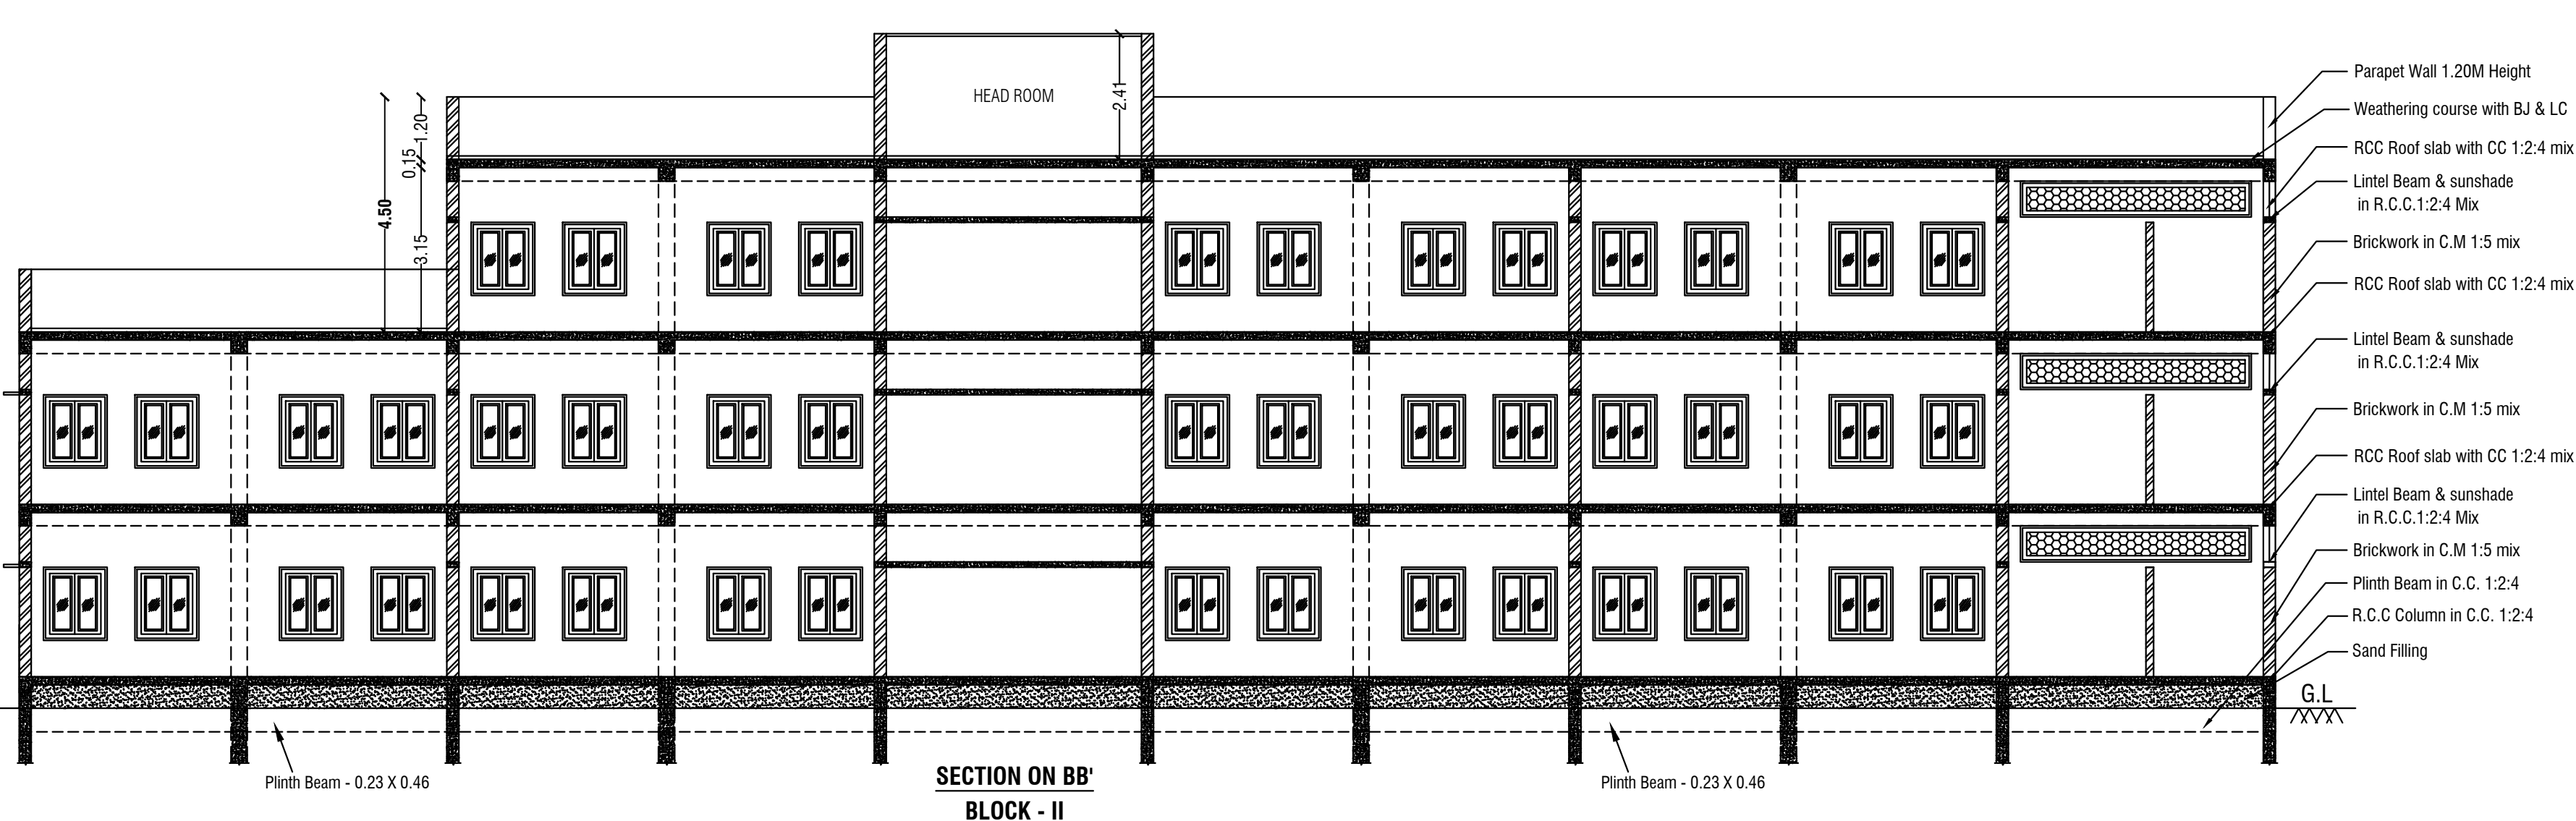
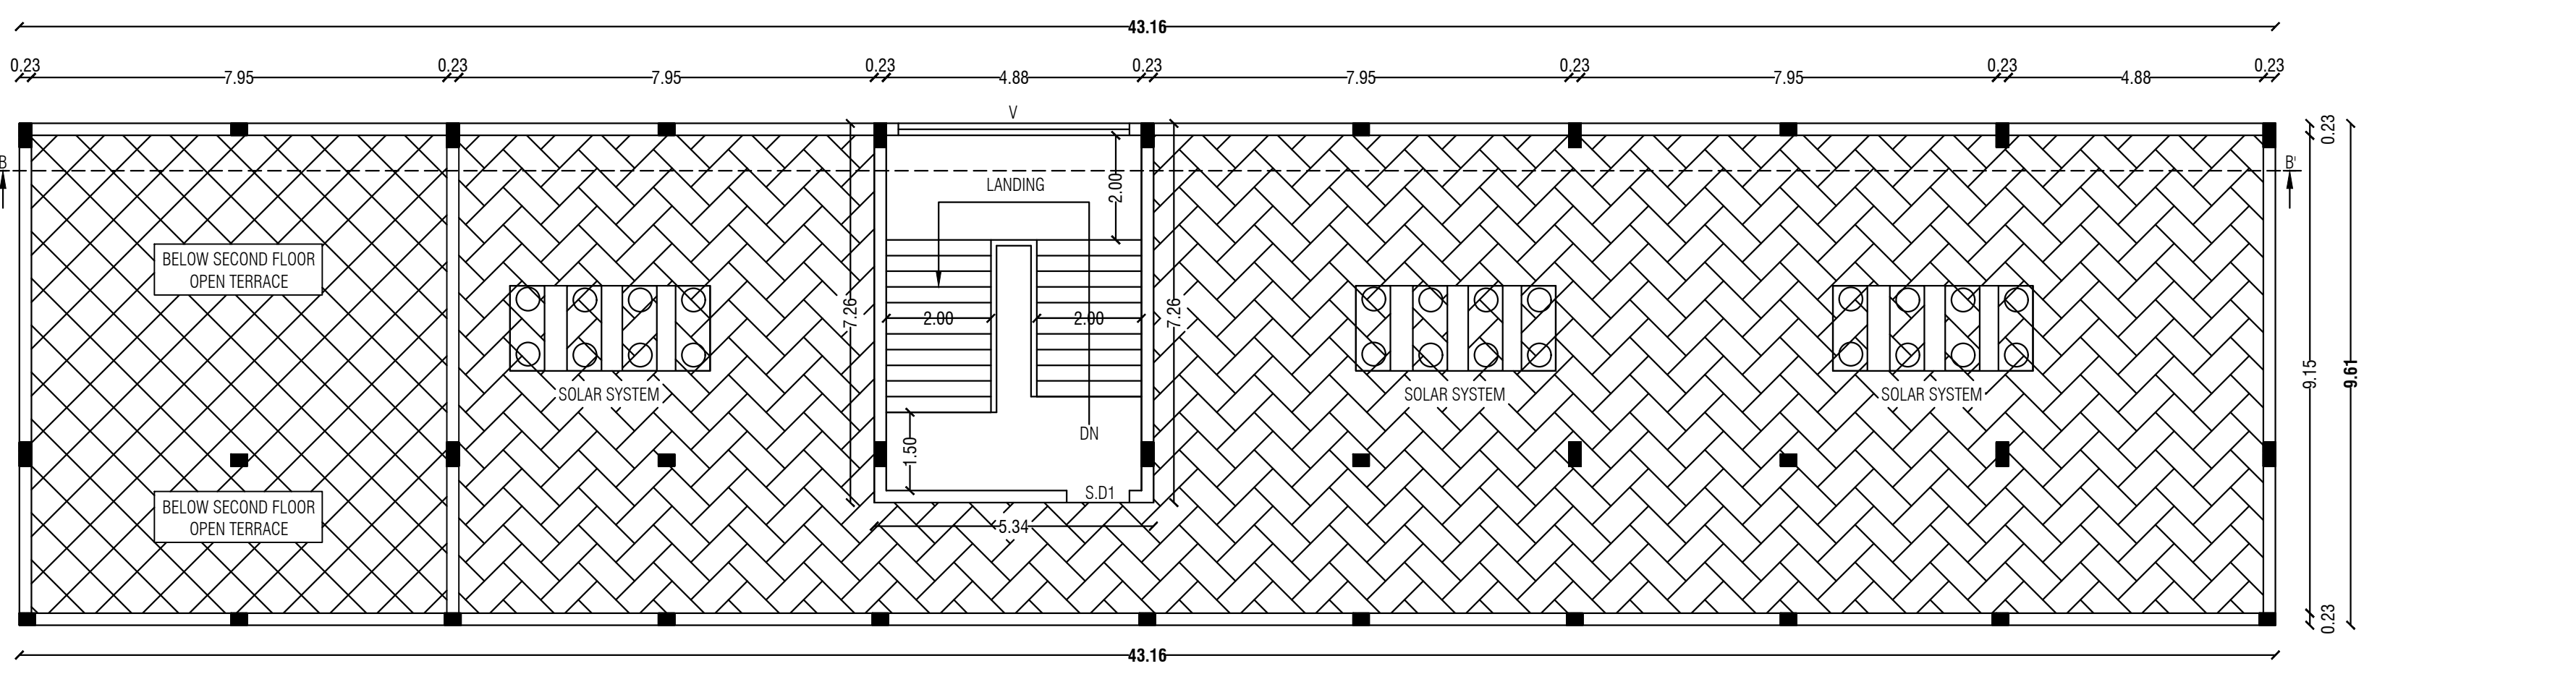
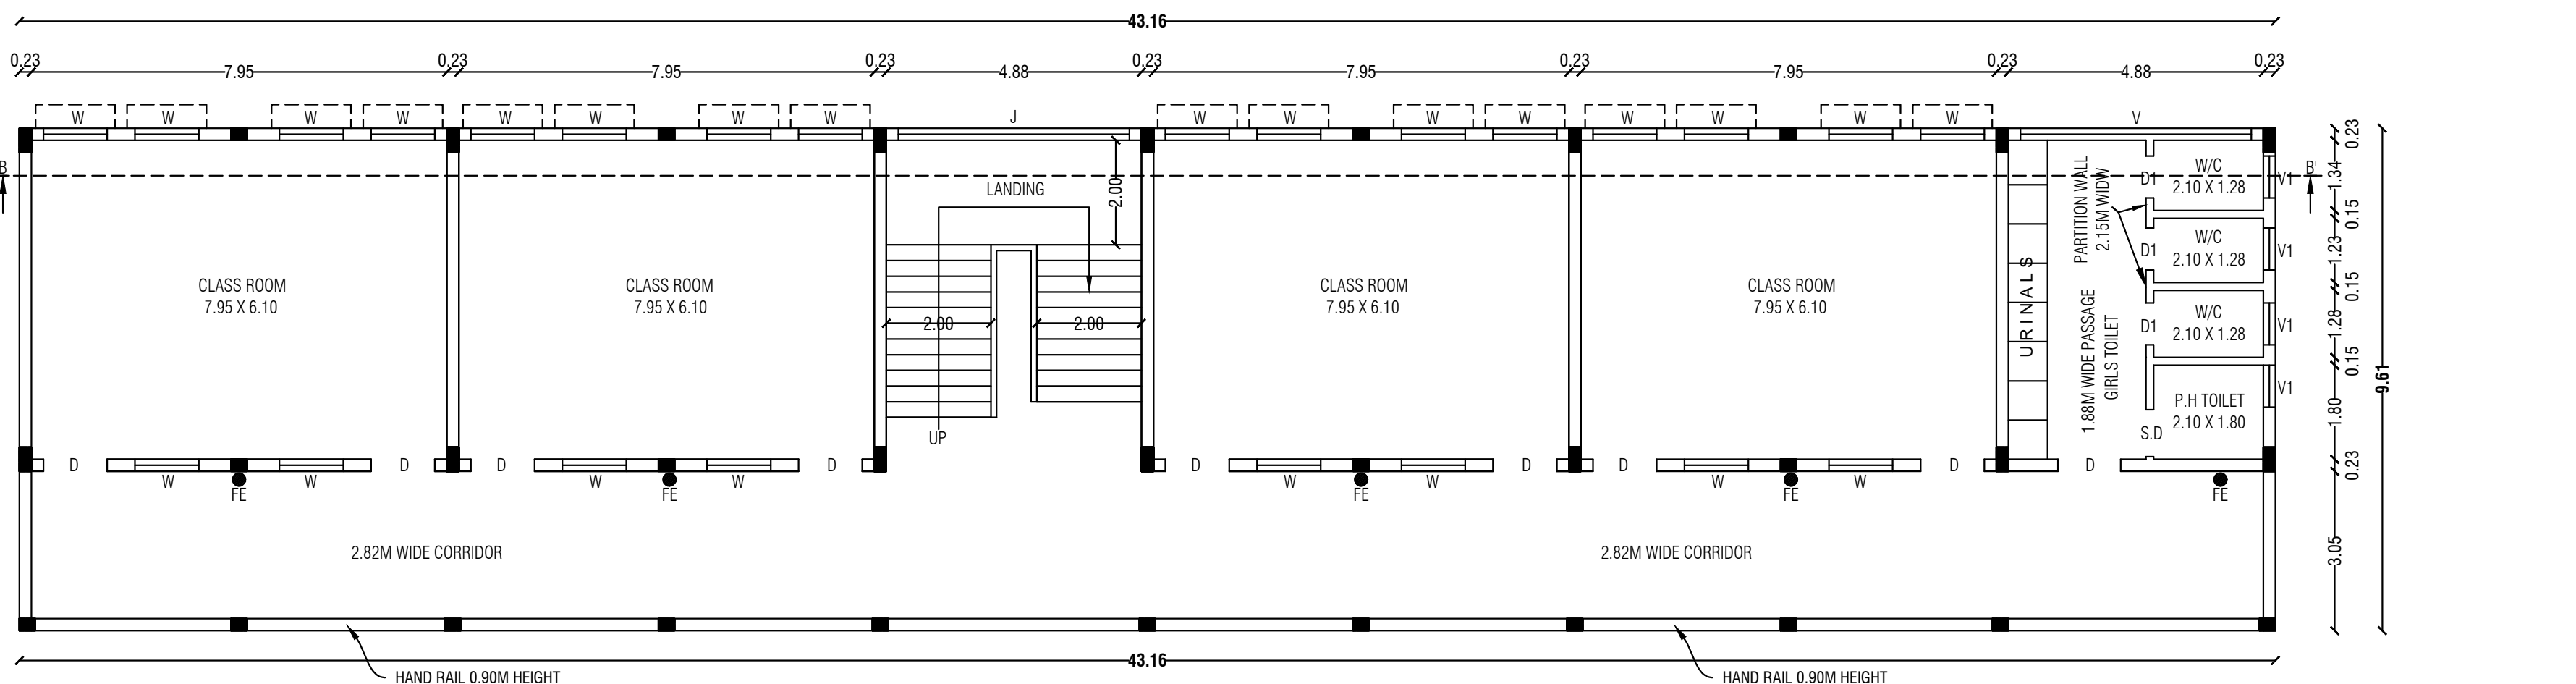
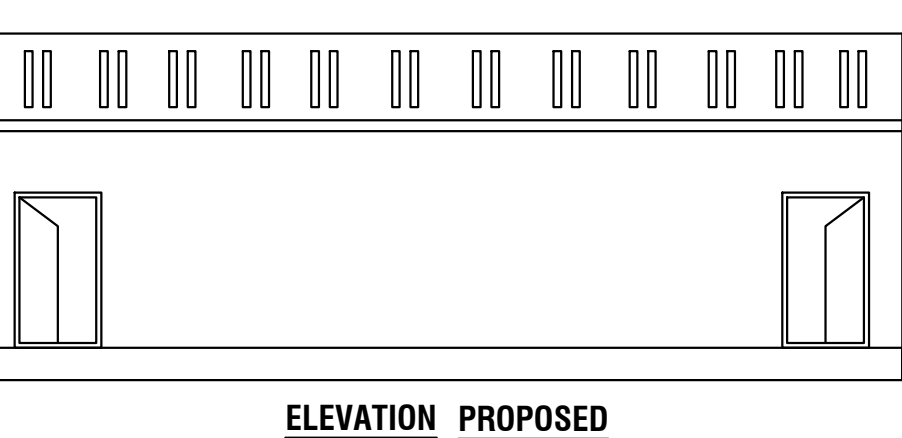
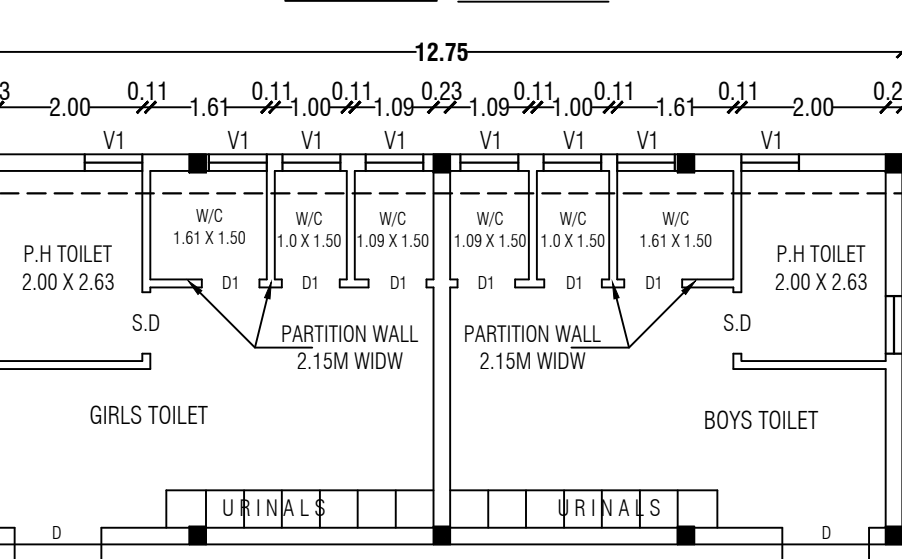
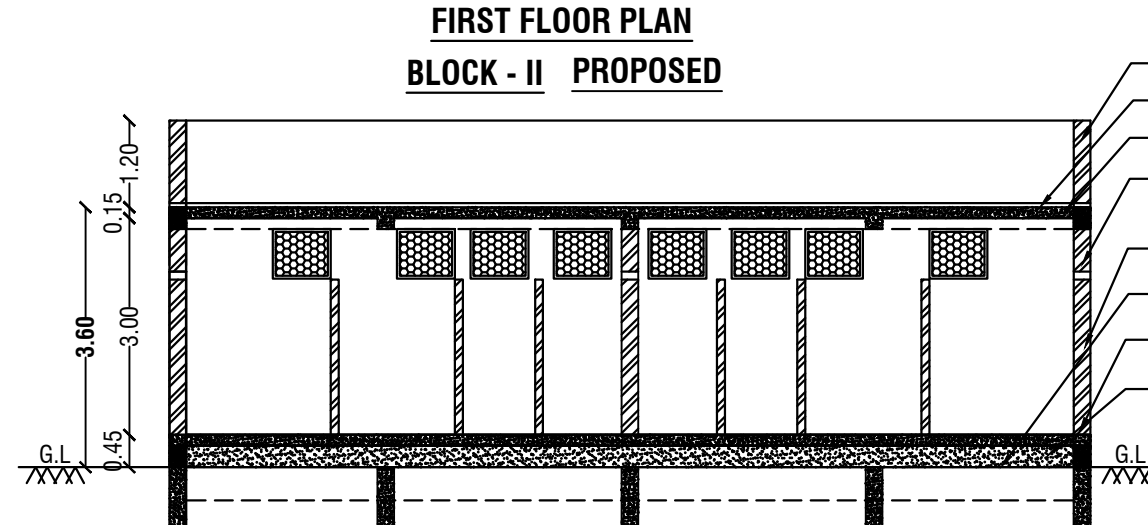
Er.M.VADIVEL.ME(Struct.), AMIE, C.Eng(I), MISTE., AIV.,
Consulting Civil Engineer, Chartered Engineer,
TN.Govt. Registered Professional of DTCP,
R.E-II-01/2023, R.S.E-II-21/2020, R.C.E-27/2020, R.D-06/2020,
R.E.(G-3), DMC No.037/LS/2019/00004, CCMC No.004/2021,
DMV CONSTRUCTION,
#19/17, 1st Floor, Annamalai Street, Near Municipality Office,
Dharmapuri - 636701, Cell: 8122 101 282, 9443 101 282.
E-Mail : dmvmconstruction.dp@gmail.com

REGISTERED STRUCTURAL ENGINEER

Er.M.VADIVEL.ME(Struct.), AMIE, C.Eng(I), MISTE., AIV.,
Consulting Civil Engineer, Chartered Engineer,
TN.Govt. Registered Professional of DTCP,
R.E-II-01/2023, R.S.E-II-21/2020, R.C.E-27/2020, R.D-06/2020,
R.E.(G-3), DMC No.037/LS/2019/00004, CCMC No.004/2021,
DMV CONSTRUCTION,
#19/17, 1st Floor, Annamalai Street, Near Municipality Office,
Dharmapuri - 636701, Cell: 8122 101 282, 9443 101 282.
E-Mail : dmvmconstruction.dp@gmail.com

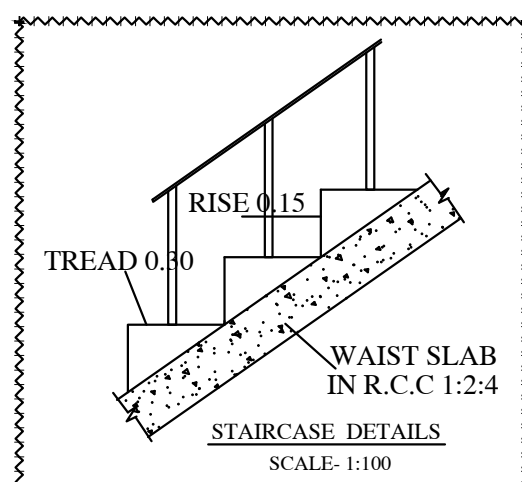
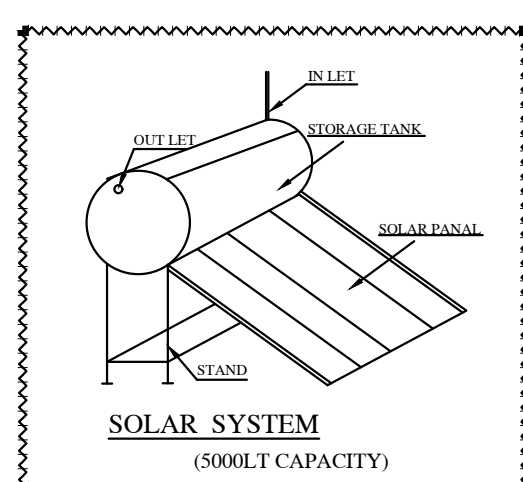
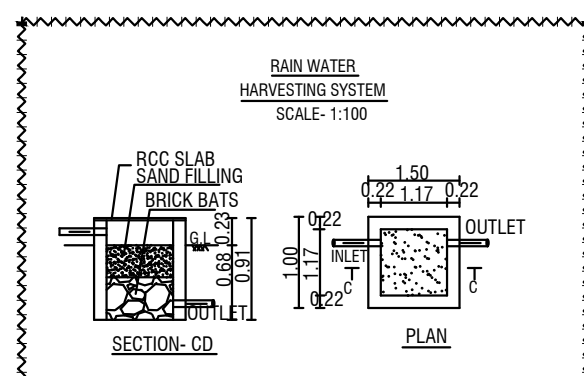
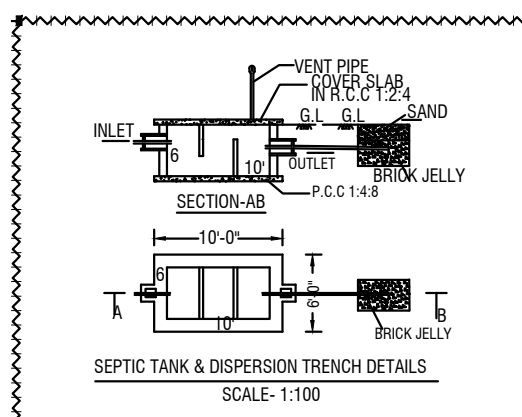
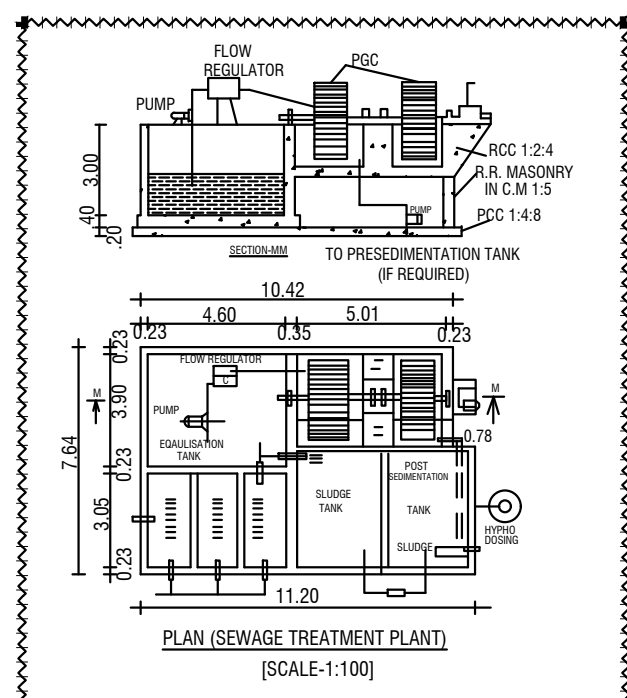
REGISTERED ENGINEER

Er.M.Vadivel. ME(Struct.), AMIE., C.Eng(I), MISTE., AIV., - D.M.V Construction - 8122 101 282, 9443 101 282.

**ELEVATION
BLOCK - II****SECOND FLOOR PLAN
BLOCK - II
PROPOSED****GROUND FLOOR PLAN
BLOCK - II
PROPOSED****SECTION ON BB'
BLOCK - II****OPEN TERRACE FLOOR PLAN
BLOCK - II
PROPOSED****FIRST FLOOR PLAN
BLOCK - II PROPOSED****ELEVATION PROPOSED****GROUND FLOOR PLAN
PROPOSED TOILET BLOCK - III****SECTION ON - CC'
PROPOSED**

KEY	
FE	FIRE EXTINGUISHER
LB	LONG BELL
DW	DRINKING WATER
EL	EMERGENCY LIGHT
FA	FIRE ALARM
FH	FIRE HYDRANT

Schedule of Joineries		
D	Door	1.23 X 2.15
D1	Door	0.80 X 2.15
S.D	Sliding Door	0.90 X 2.15
S.D1	Steel Door	1.20 X 2.15
W	Window	1.22 X 1.40
J	Jolly	4.42 X 1.40
V	Ventilator	4.42 X 0.60
V1	Ventilator	0.80 X 0.60

**WAIST SLAB
IN R.C.C 1:2:4
STAIRCASE DETAILS
SCALE:1:100****SOLAR SYSTEM
(5000LT CAPACITY)
SCALE:1:100****RAIN WATER
HARVESTING SYSTEM
SCALE:1:100****SEPTIC TANK & DISPERSION TRENCH DETAILS
SCALE:1:100****PLAN (SEWAGE TREATMENT PLANT)
SCALE:1:100**

