
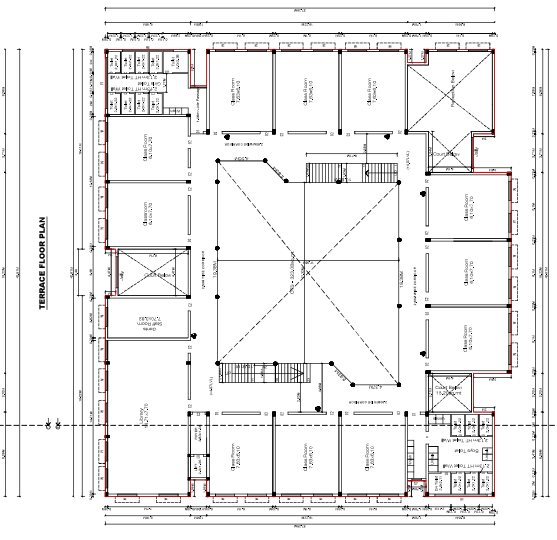
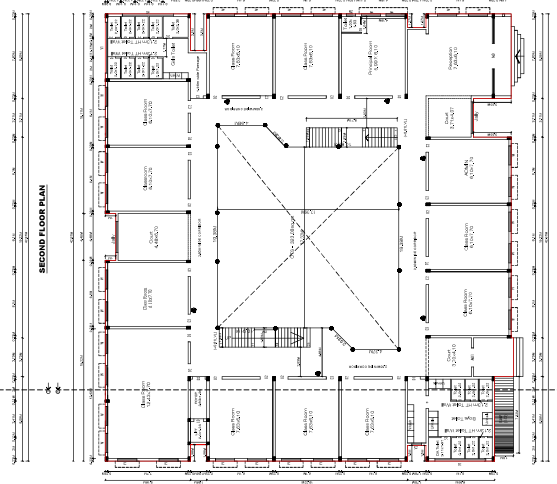
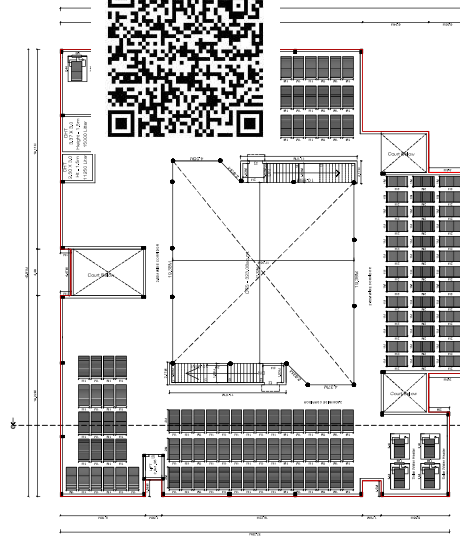
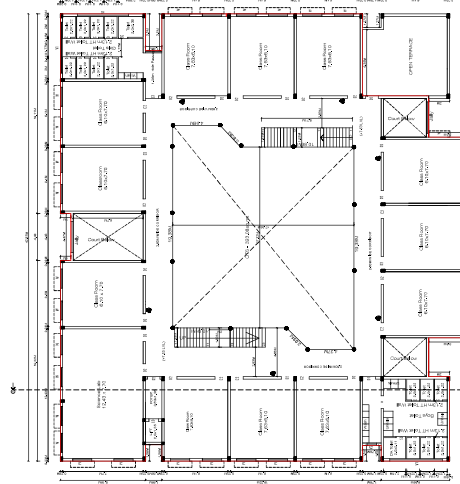
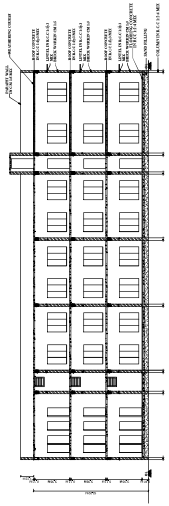
 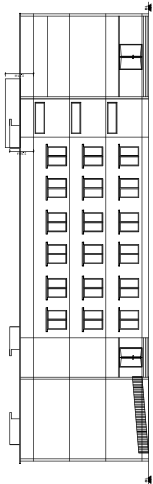


PLAN SHOWING THE PROPOSED CONSTRUCTION OF SCHOOL BUILDING FOR SREE MURUGAN EDUCATIONAL TRUST IN S.F.NO.368/2B, 368/3, 368/5A, AT VIGNESH NAGAR, SEELAPADI VILLAGE & PANCHAYAT, DINDIGUL WEST TALUK, DINDIGUL DISTRICT.

SCALE 1:100



GROUND FLOOR PLAN

FIRST FLOOR PLAN

SECOND FLOOR PLAN

TERRACE FLOOR PLAN



SITE EXTENT				SHEET NO - 1/2	
AREA OF THE DOCUMENT				- 12787.96 SQMT	
AREA OF THE PLOT				- 12760.00 SQMT	
FLOOR	FSI SQMT	NON FSI SQMT	TOTAL SQMT		
GROUND FLOOR	1297.92	-	1297.92		
FIRST FLOOR	1150.44	-	1150.44		
SECOND FLOOR	1146.95	-	1146.95		
TERRACE FLOOR	-	53.45	53.45		
TOTAL	3595.31	53.45	3648.76		
PLOT COVERAGE (PC) = $1297.92 / 12760.00 \times 100 = 10.17\%$					
TOTAL FLOOR SPACE INDES (FSI) = $3595.31 / 12760.00 = 0.2811 < 2$					
JOINERIES				METRE	
MD - MAIN DOOR				2.44 X 2.13	
NDI - MAIN DOOR				1.83 X 2.13	
D2 - DOOR				1.22 X 2.13	
D1 - DOOR				1.22 X 2.13	
D - DOOR				0.76 X 2.13	
SD - DOOR				0.91 X 2.13	
LD - LIFT DOOR				0.91 X 2.13	
O - OPEN				1.22 X 2.13	
W - WINDOW				1.83 X 1.83	
V1 - VENTILATION				4.88 X 0.91	
V2 - VENTILATION				0.91 X 0.91	
J - R.C.C. Jolly				3.00 X 0.91	

NOTE

1. BORE WELL WITH MOTOR, WATER TANK AND CORPORATION WATER SUPPLY WILL BE PROVIDED.
2. SULLAGE WASTE FROM TOILET WILL BE CONNECTED EXISTING
3. RAIN WATER PERCOLATION PITS OF ANCS. PROVIDED @ 130 SQM OF PLINTH AREA @ 3M C/C
4. RAIN WATER PERCOLATION BED 1.0M WIDE WILL BE PROVIDED @ 130 SQM OF PLINTH AREA @ 3M C/C
5. PERCOLATION BED OUT SIDE ALONG PLINTH TO BE PROVIDED
6. OUTER PAVEMENTS SLOPING TO WARDS RAIN WATER PERCOLATION PIT ALONG PLINTH
7. RAIN WATER TAKEN TO THE BORE WELL THROUGH 150MM DIA PIPES.
8. RAIN WATER COLLECTED THROUGH OPEN TERRACE SHALL BE COLLECTED THROUGH PIPES AND LED INTO A FILTER PIT (SIZE 80X60X60CM) WITH APPROPRIATE FILTER MATERIAL AND THEN LED INTO COLLECTION TANK.
9. SOLAR WATER HEATER LINE ARRANGEMENTS WILL BE PROVIDED.
10. ALL DIMENSIONS ARE IN METRE.
11. FA - FIRE ALARM PROVIDED.
12. FE - FIRE SAFETY MEASURES PROVIDED.
13. SB - SAND BUCKET PROVIDED.

ARCHITECT

APPLICANT

REGISTERED ENGINEER



STRUCTURAL ENGINEER

LS ENGINEER

Online Application Number - SWP/BPA/21384/2024
ROC No. - SWP/BPA/21384/2024-SP
Plan Permission Number - 077/2024/SP

DATE APPROVAL: 04/07/2024
ONLINE APPLICATION NO: SWP/BPA/21384/2024
By: S. Hemu, S. E., Vignesh Nagar, Dindigul District, Tamil Nadu
Numbered as: SWP/BPA/21384/2024-SP
Date Approved: 04/07/2024
Drawing Survey Reference No: 78140019

 SCALE 1:100

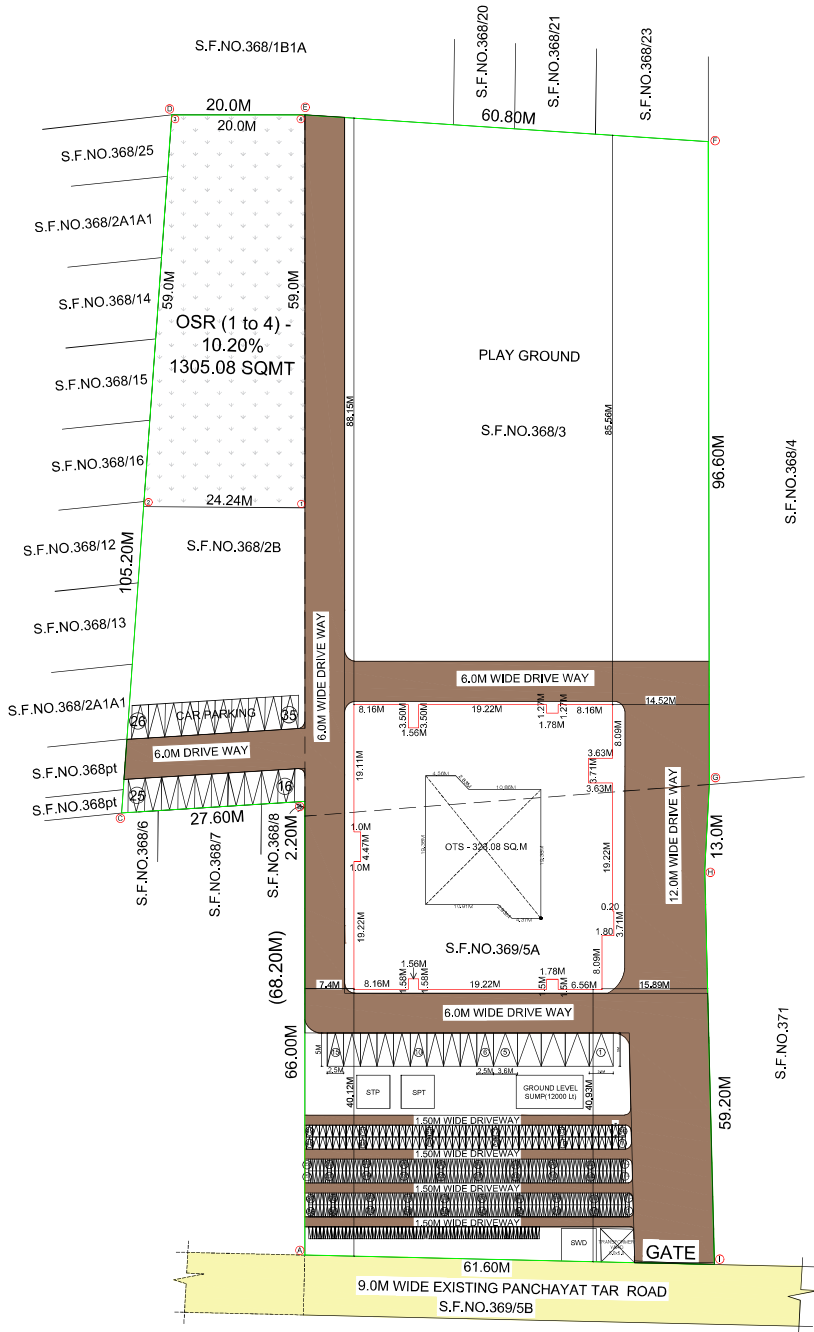

LS ENGINEER

Signature valid

