






SITE PLAN
SCALE 1:400

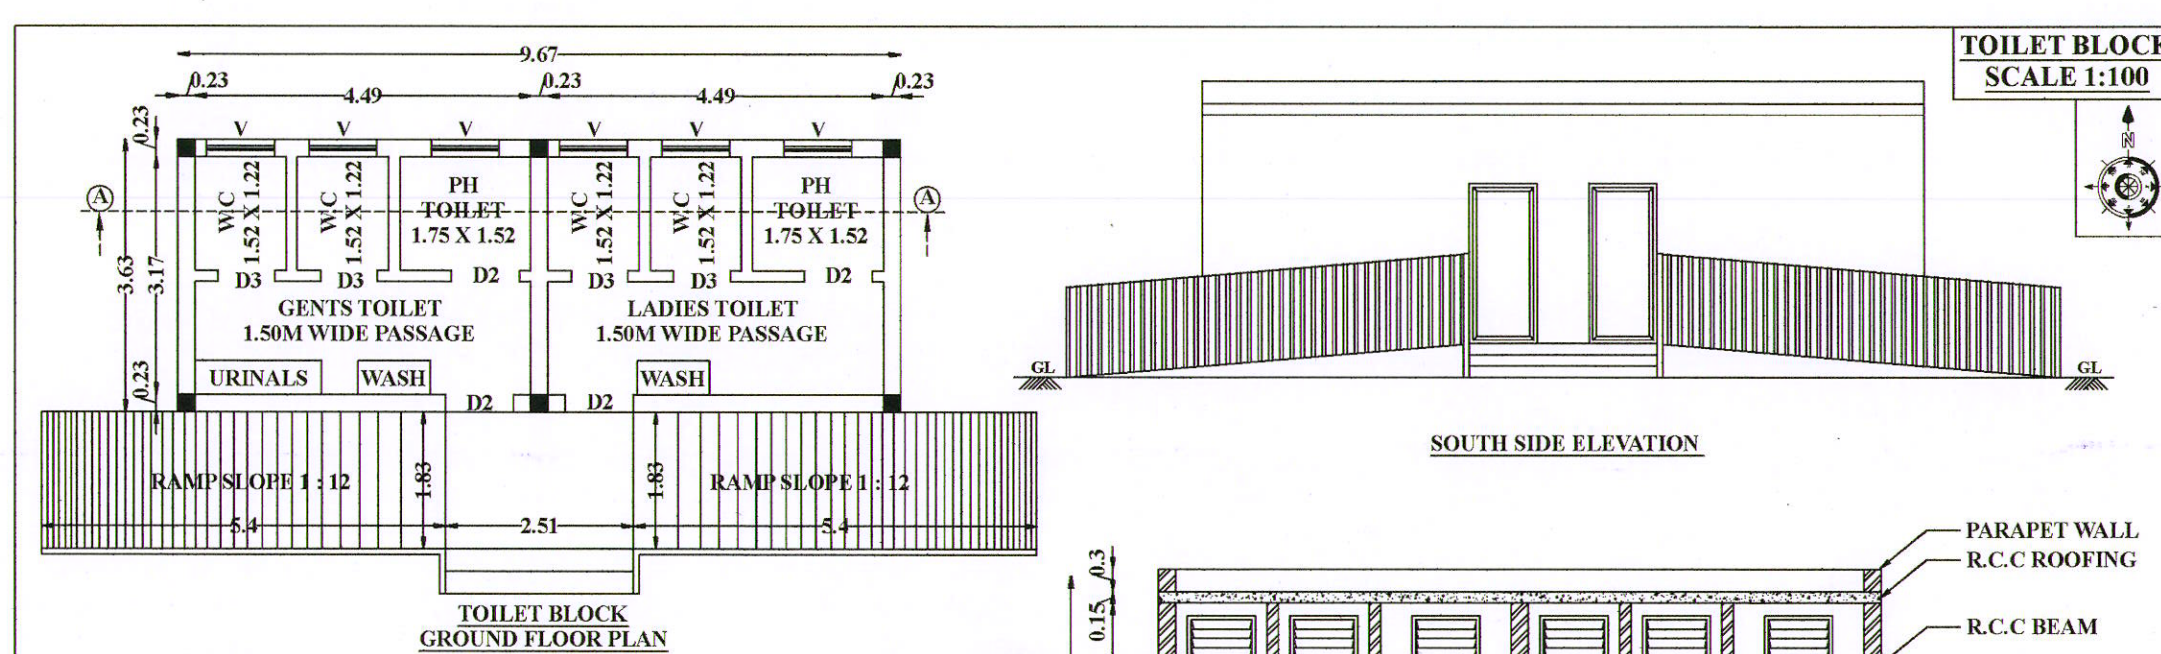


TOILET BLOCK
SCALE 1:100

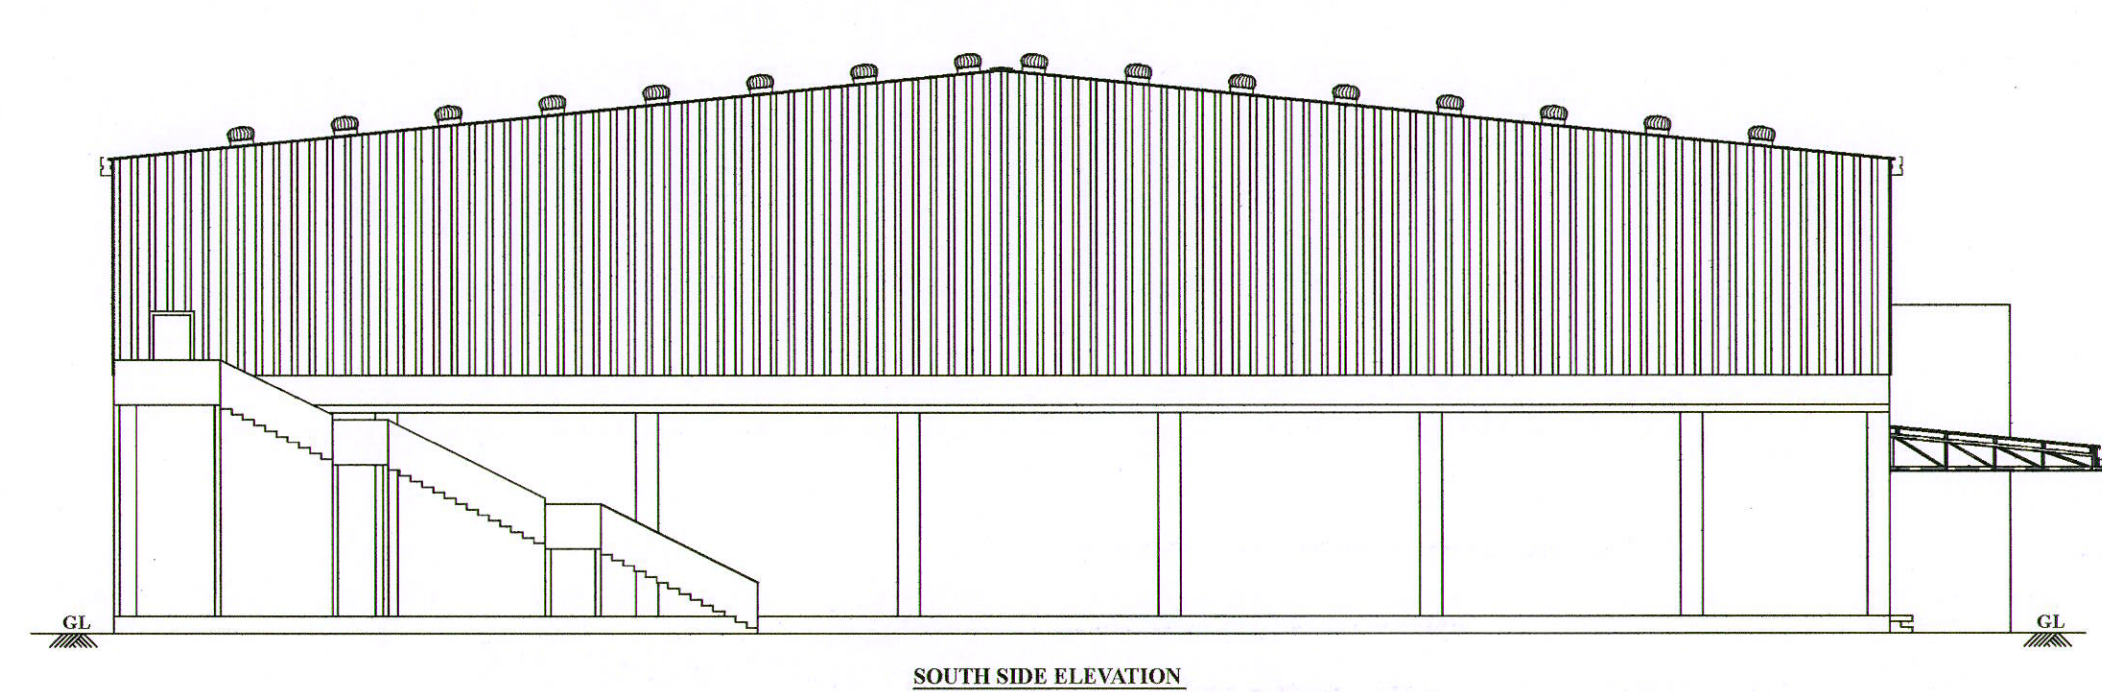


SOUTH SIDE ELEVATION

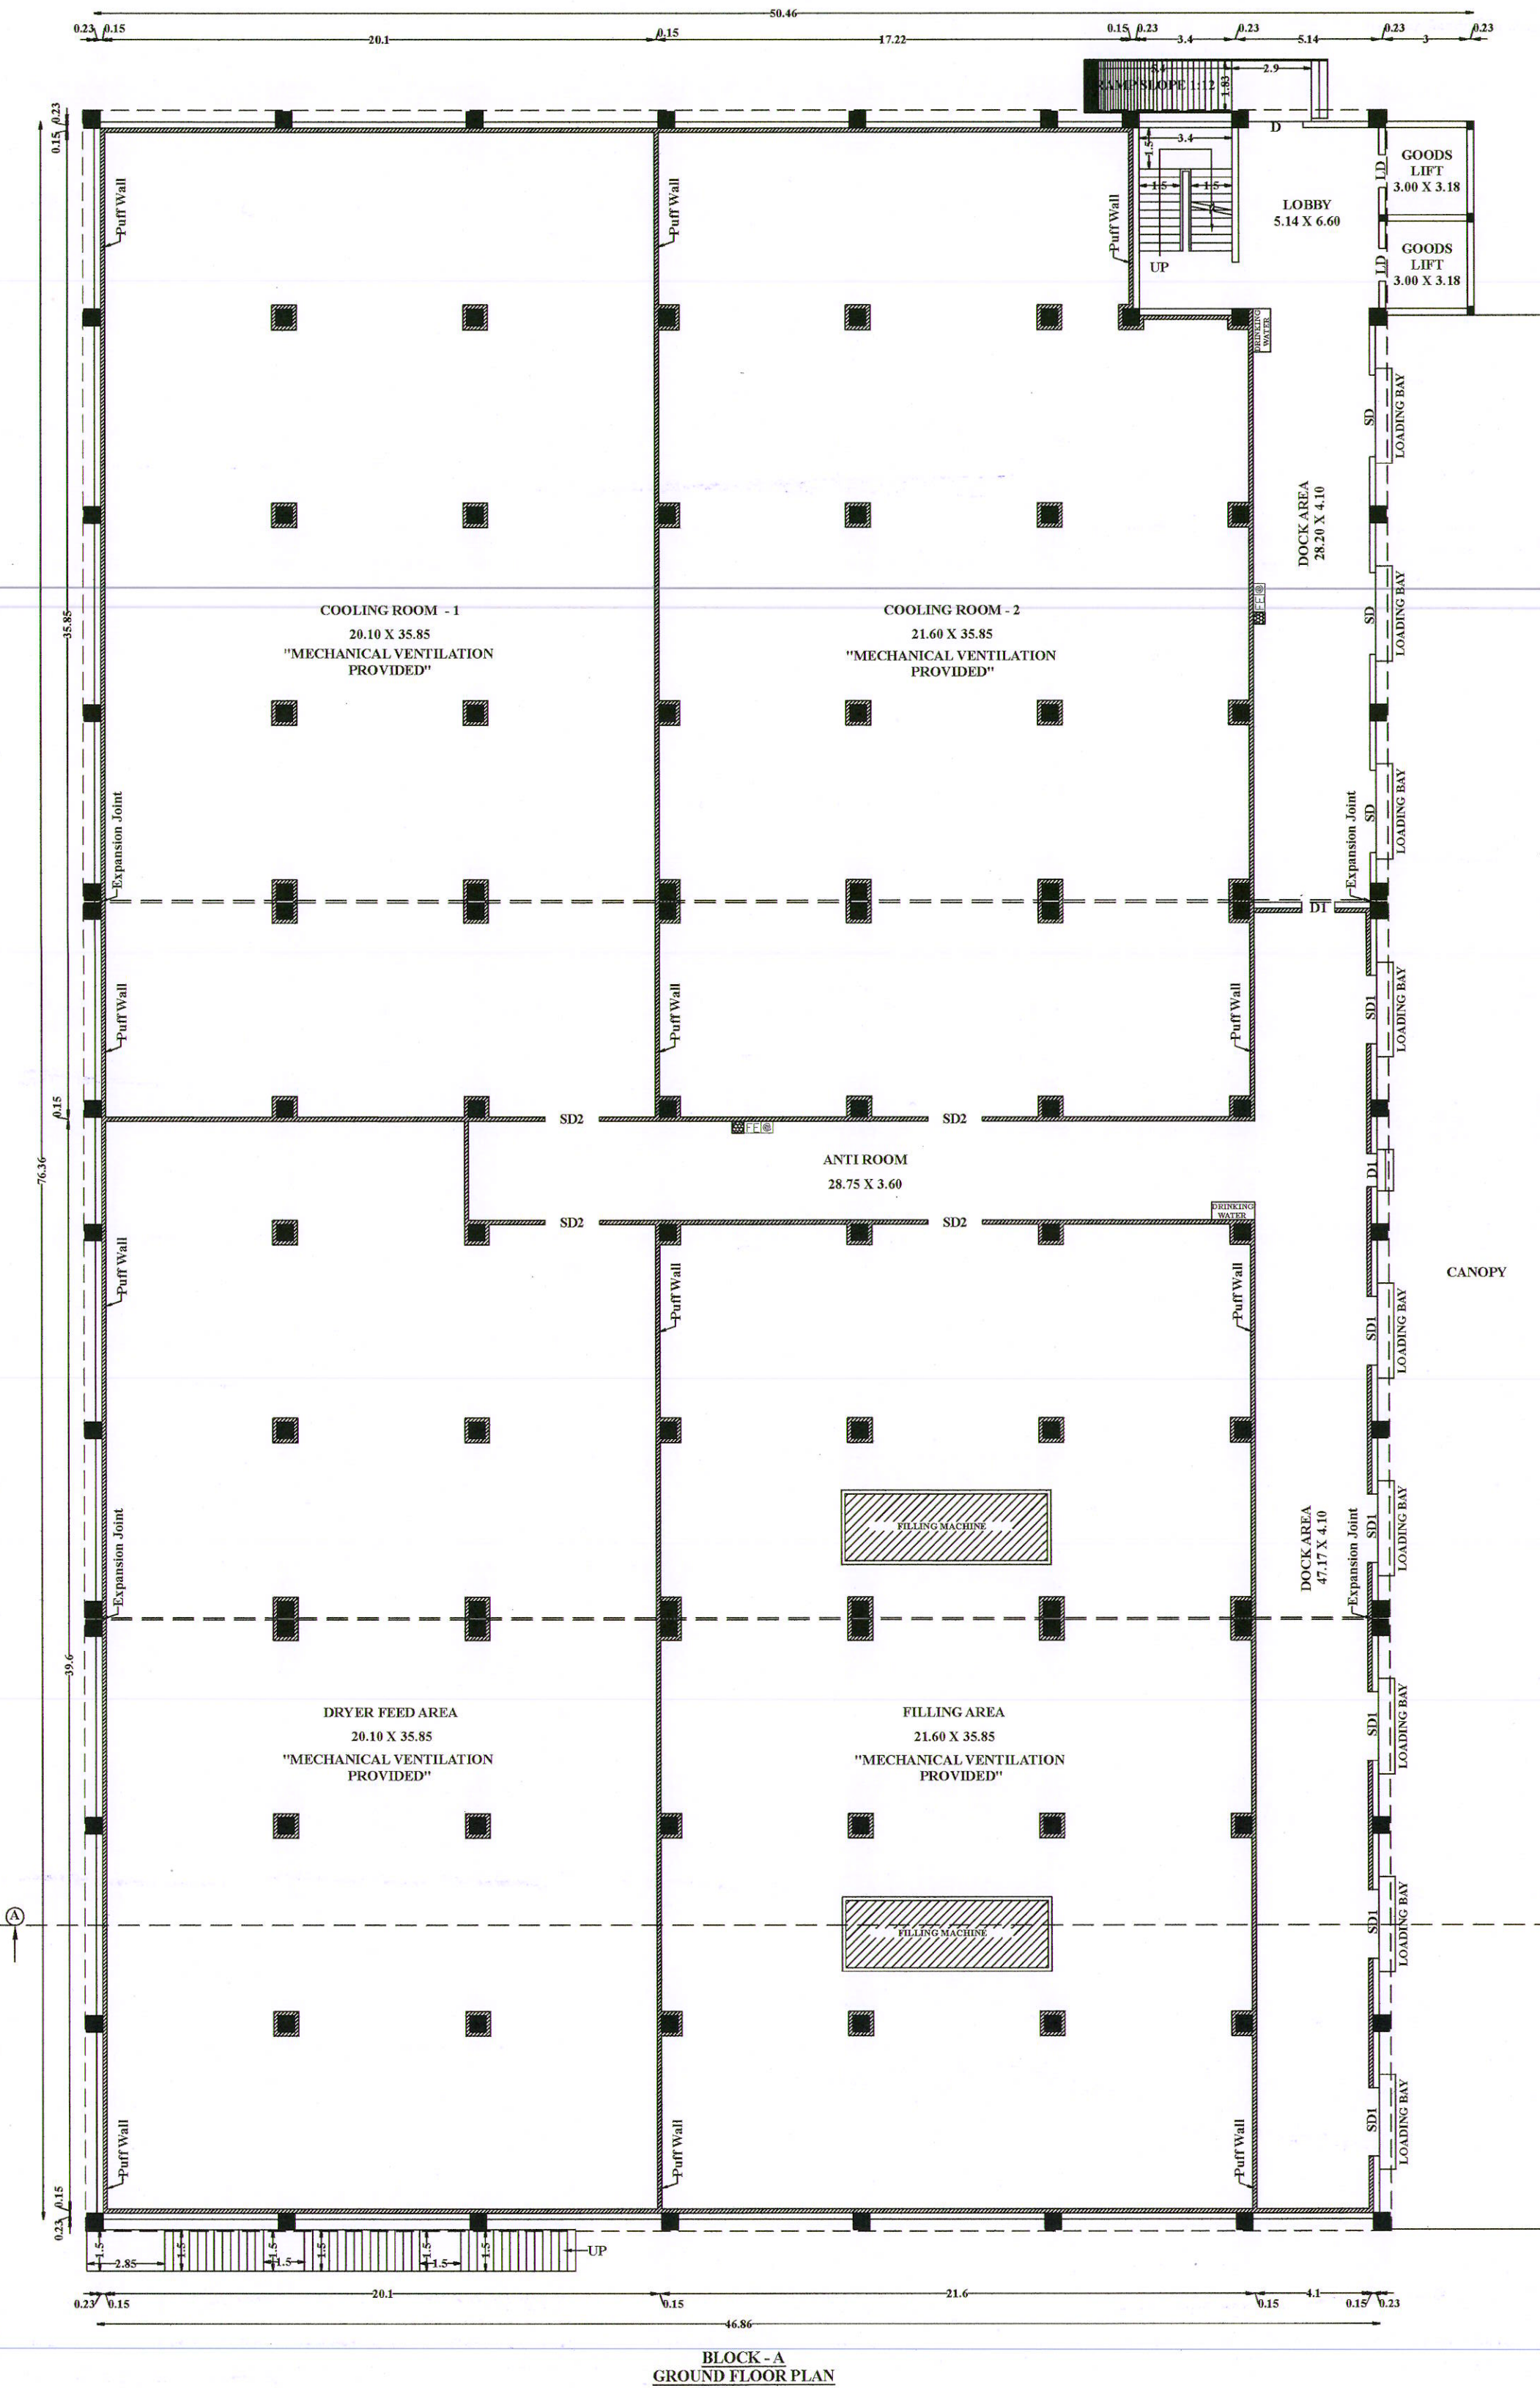

BLOCK - A
GROUND FLOOR PLAN

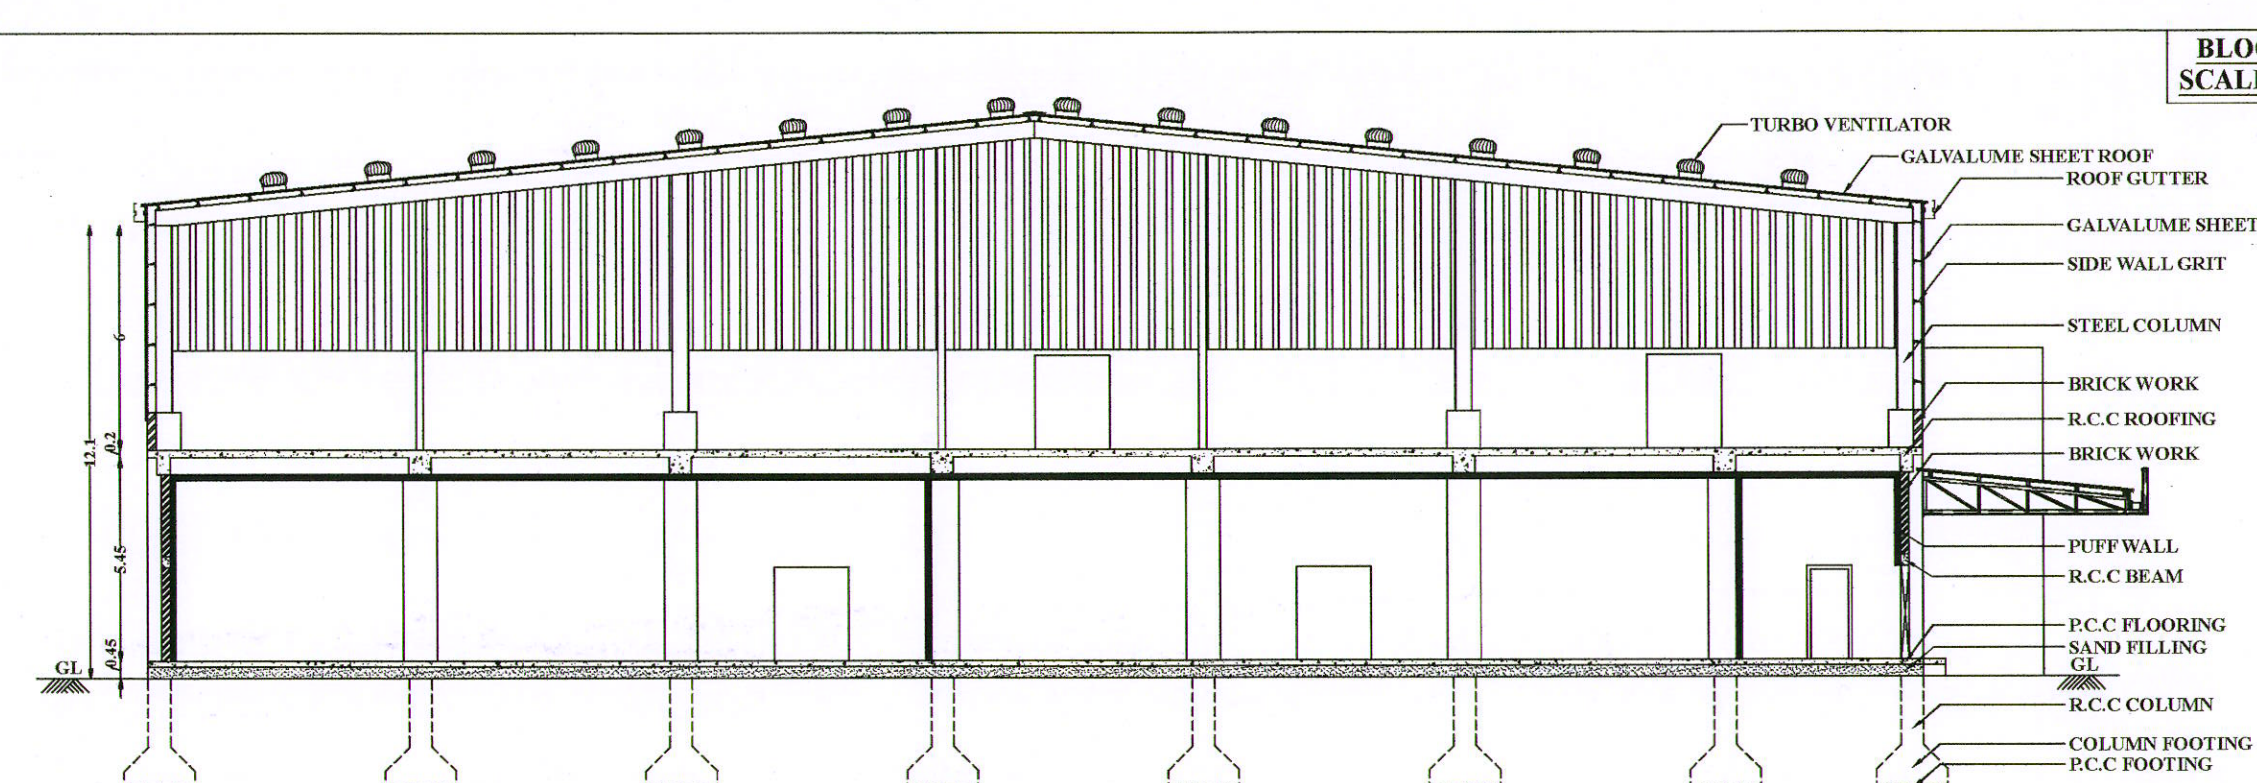

SECTION ON A-A

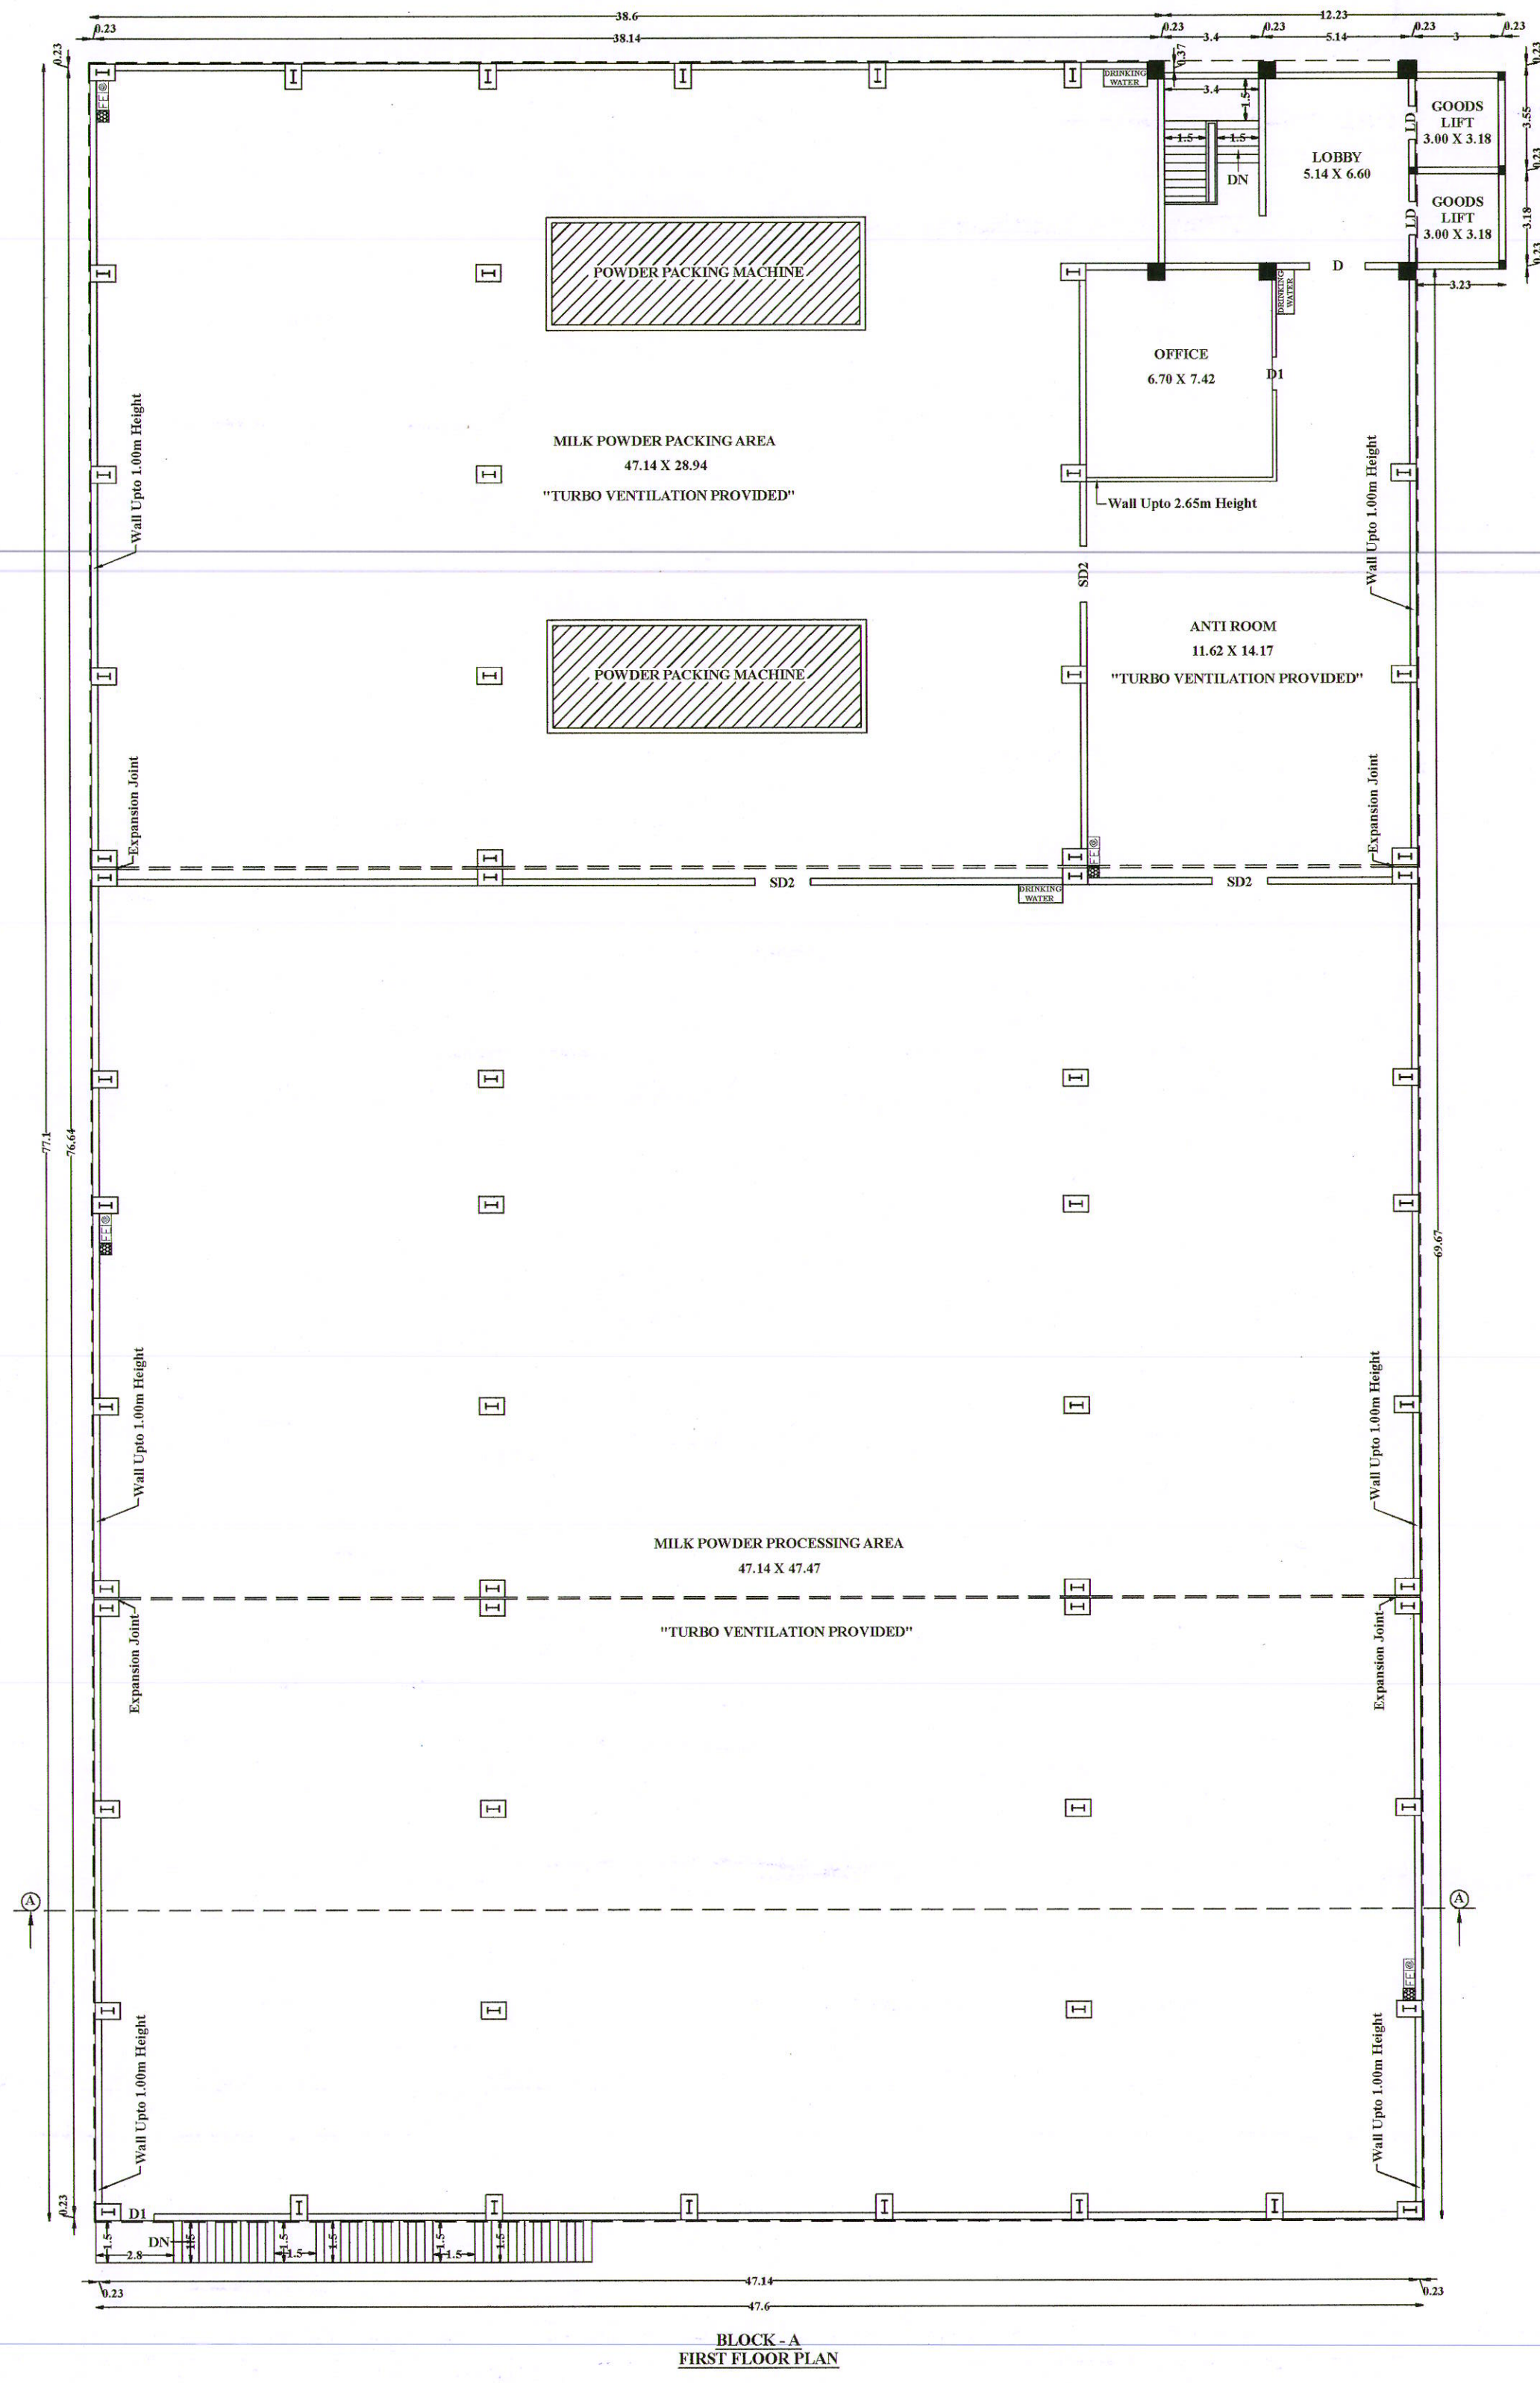

BLOCK - A
FIRST FLOOR PLAN

SITE AND DETAILED PLAN SHOWING THE PROPOSED CONSTRUCTION OF R.C.C ROOF BLOCK-A HAVING GROUND FLOOR AND FIRST FLOOR; R.C.C ROOF TOILET BLOCK HAVING GROUND FLOOR IN DAIRY AND DAIRY PRODUCT INDUSTRIAL (ORANGE CATEGORY) BUILDING WITH 750 HP IN R.S.NO.133/7B, 8, 9, 10A, 11A, 12A, 13, 14A AT PATTAKARANPALAYAM VILLAGE, PERUNDURAI TALUK, ERODE DISTRICT.

ALL DIMENSIONS ARE IN METER
ONLINE APPLICATION NO- SWP/ BFA/497254/2025
NAME OF THE APPLICANT :
M/S. MILKY MIST DAIRY FOOD PVT LTD.
BY ITS MANAGING DIRECTOR M.T.SATHISH KUMAR S/o.M.THANGAMUTHU

AREA DETAILS :
AREA AS PER PATT - 10658.00 Sqm
AREA AS PER DOCUMENT - 2.6225 ACRE (OR) 10612.89 Sqm
AREA AS PER SUPERIMPOSED - 10791.86 Sqm

S. NO	DESCRIPTION	PROPOSED BUILDING AREA IN Sqm		
		FSI AREA	NON FSI AREA	TOTAL AREA

BLOCK - A (MAIN BUILDING)				
1	GROUND FLOOR	4047.44	-	4047.44
2	FIRST FLOOR	3716.13	-	3716.13

TOILET BLOCK				
1	GROUND FLOOR	35.10	-	35.10
GRAND TOTAL		7798.67	-	7798.67

FLOOR SPACE INDEX		FSI AREA	7798.67	0.73 < 2.0
OSR PROVIDED		SITE AREA	10612.89	

OSR REQUIRED		1079.19 Sq.m (10.00%)		
OSR PROVIDED		1106.29 Sq.m (10.25%)		

HEIGHT OF THE BUILDING - 12.10M

PARKING AREA DESCRIPTION	AREA	REQUIRED	PROVIDED
ONE CAR SPACE FOR EVERY 150 SQ.M OF OFFICE AREA	49.71	1	2
ONE TWO WHEELER SPACE FOR EVERY 75 SQ.M OF WORKSHOP AREA	7713.86	103	110
ONE CYCLE SPACE FOR EVERY 75 SQ.M OF WORKSHOP AREA	7713.86	103	105
ONE LORRY SPACE FOR EVERY 750 SQ.M OF CLASS ROOM AREA	7713.86	11	12

JOINERY DETAILS			
1	DOOR - D	2.00 X 2.13	
2	DOOR - D1	1.20 X 2.13	
3	DOOR - D2	0.90 X 2.13	
4	DOOR - D3	1.83 X 1.37	
5	SLIDING DOOR - SD1	2.50 X 2.13	
6	SLIDING DOOR - SD2	2.00 X 2.13	
7	VENTILATOR - V	0.90 X 0.60	
8	LIFT DOOR - LD	1.20 X 2.13	

REFERENCE	COLOR INDEX
FIRE ALARM SYSTEM	SITE BOUNDARY
HOSE REEL	EXISTING ROAD
FIRE FIGHTING EQUIPMENT	PROPOSED BUILDING
DRINKING WATER	DRIVE WAY
	OSR

No Of Workers - 20 Nos	
Male	15 Nos
Female	5 Nos

MACHINERY DETAILS			
Name	No's	Hp	Total
IDMC REFRIGERATION	1	350.00	350.00
POWDER PACKING MACHINE	2	100.00	200.00
FILLING MACHINE	2	100.00	200.00
TOTAL HP			750.00

Er.D.NITHYADEVI, I.E.
Registered Engineer - TD/REGD-117004/12014
Registered Structural Engineer - TD/REGD-117004/12014
51100 - 4A, Ganga Nagar, Erode District, Tamil Nadu
TIRUPPUR - 641 005, Call : 9482525167
Email id : nithyadeviengineer@gmail.com

REGISTERED ENGINEER

Er.D.NITHYADEVI, I.E.
Registered Engineer - TD/REGD-117004/12014
Registered Structural Engineer - TD/REGD-117004/12014
51100 - 4A, Ganga Nagar, Erode District, Tamil Nadu
TIRUPPUR - 641 005, Call : 9482525167
Email id : nithyadeviengineer@gmail.com

REGISTERED STRUCTURAL ENGINEER

For Milky Mist Dairy Food Pvt Ltd

Managing Director

APPLICANT